


AREA TYPE:


- 2 BED APARTMENT TYPE A-2B4P-1
- 2 BED APARTMENT TYPE A-2B4P-12
- CIRCULATION

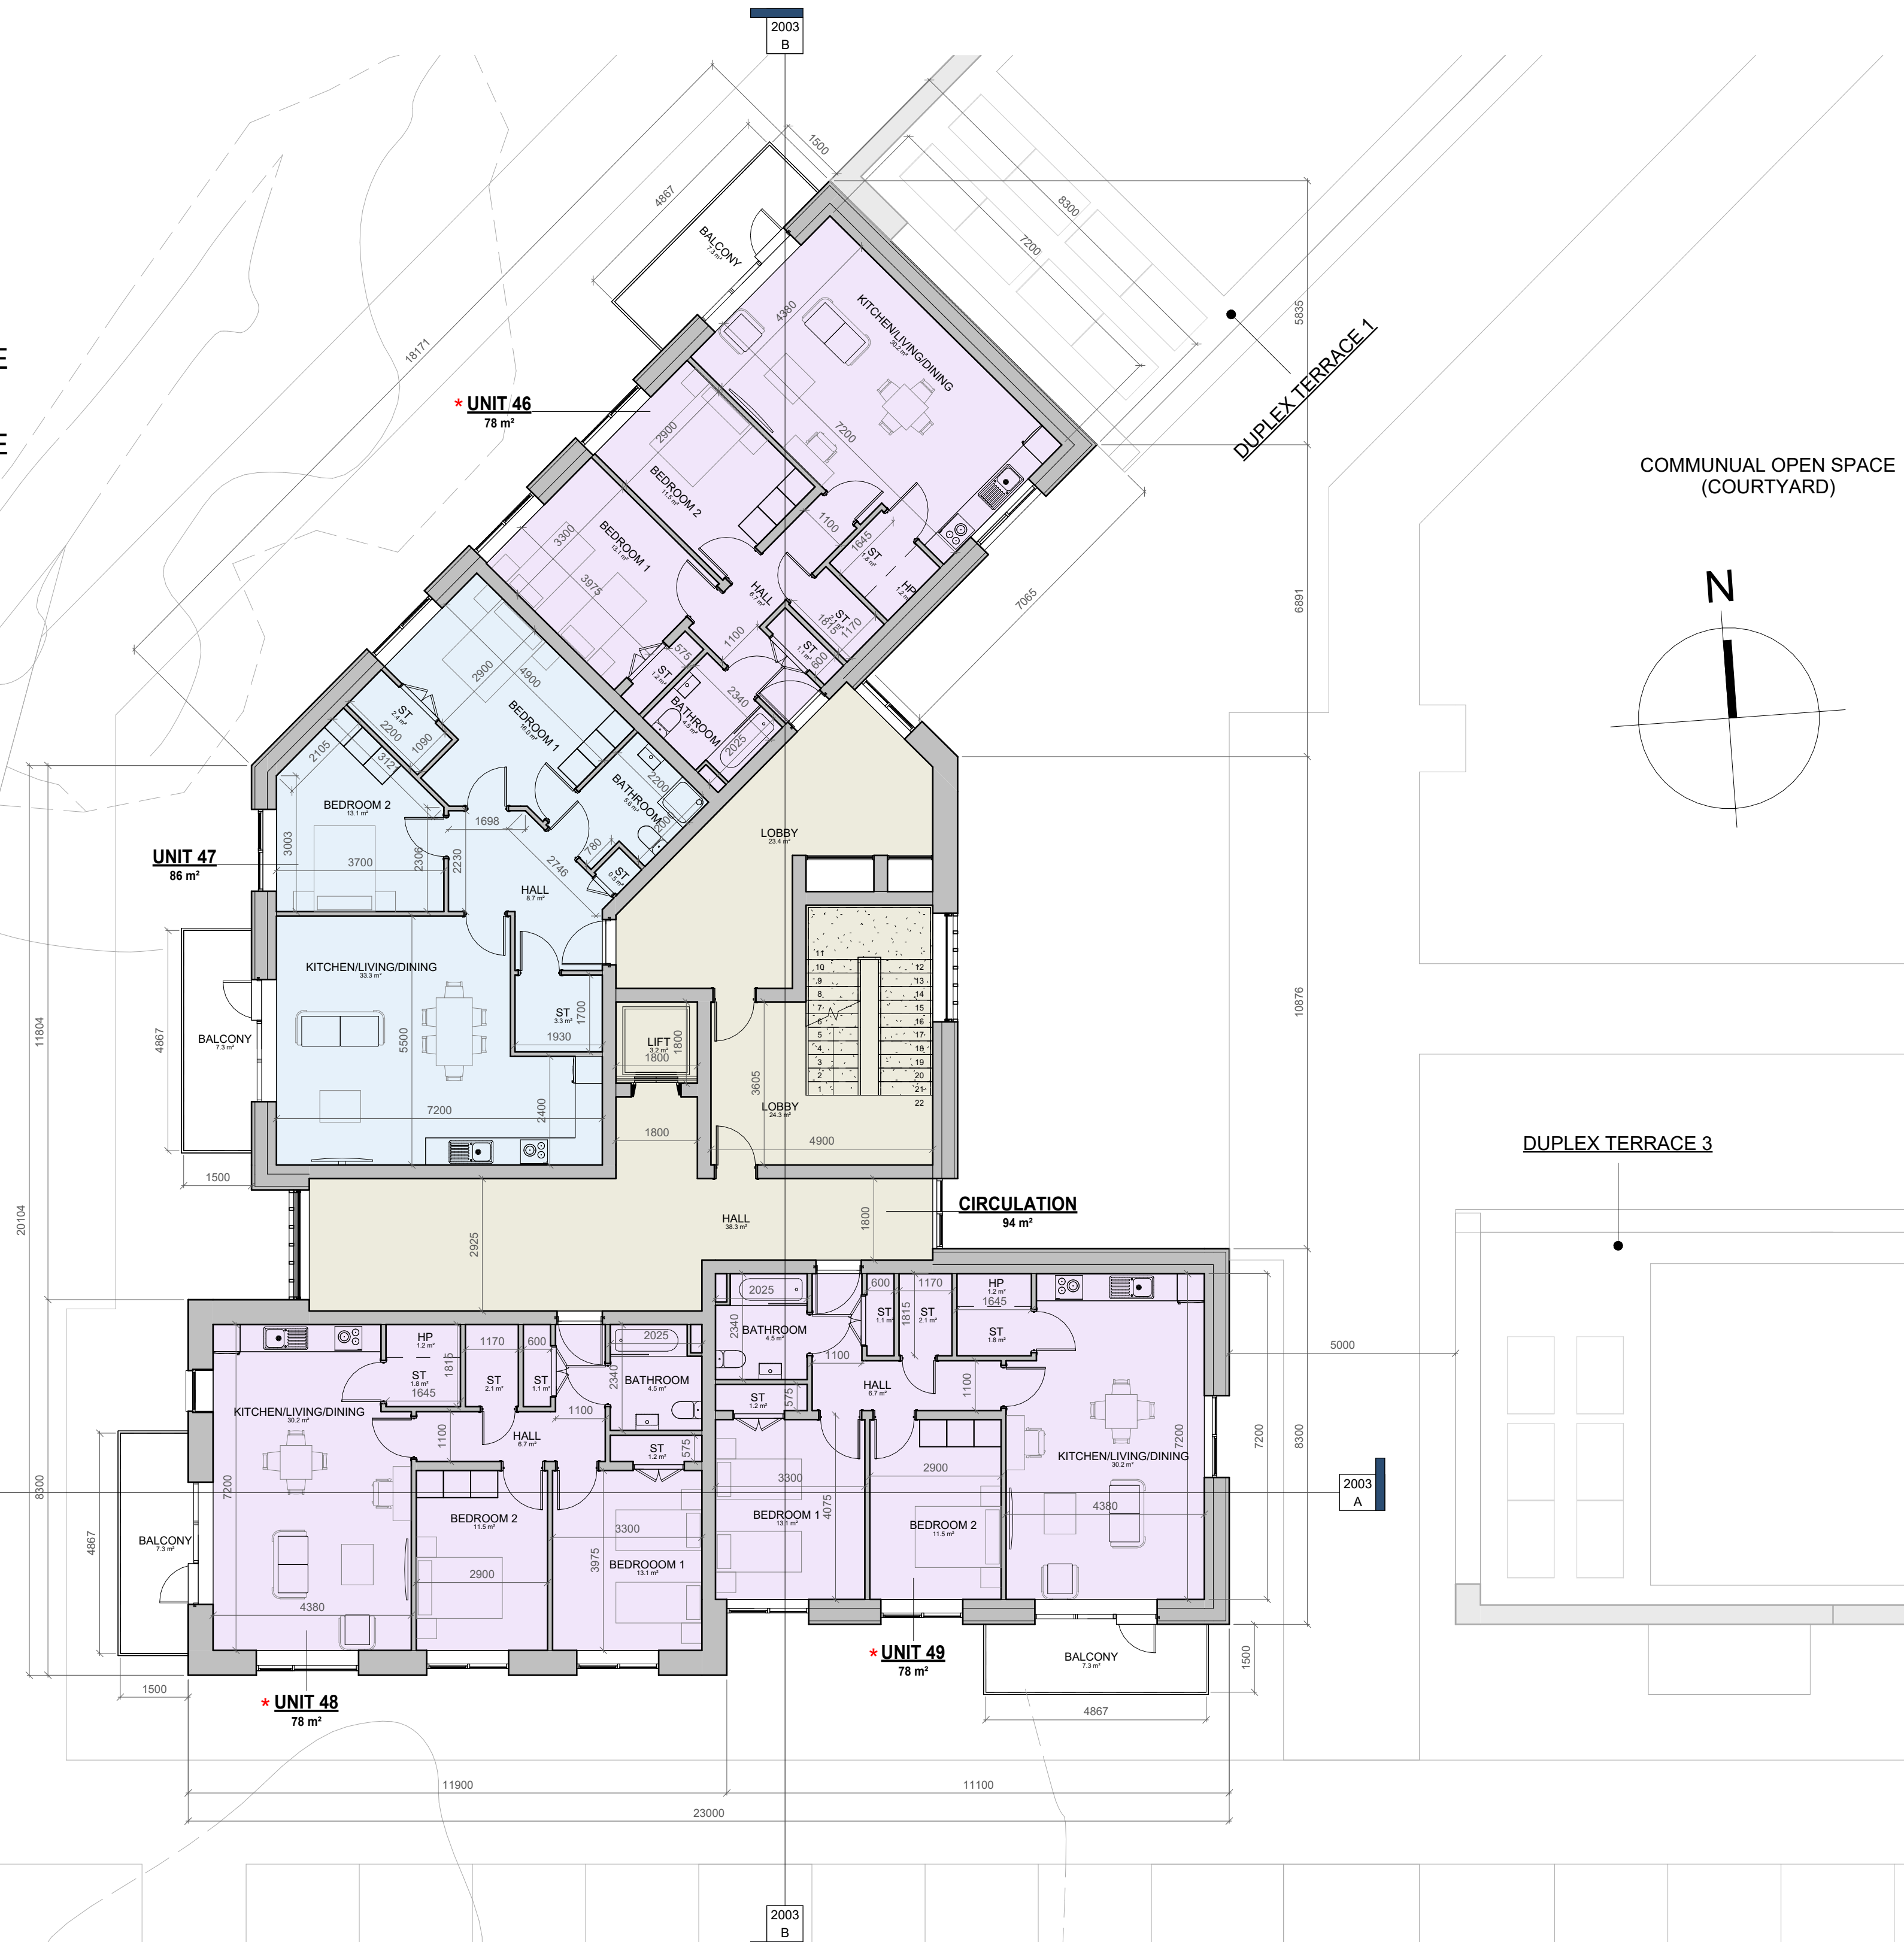

GENERAL NOTES

DO NOT SCALE FROM DRAWINGS. WORK TO FIGURED DIMENSIONS ONLY. ARCHITECT TO BE NOTIFIED OF ANY DISCREPANCIES.

THIS DRAWING TO BE READ IN CONJUNCTION WITH ALL ARCHITECT'S DRAWINGS, SPECIFICATIONS CONSULTANTS' DESIGN TEAM DRAWINGS AND SPECIFICATIONS.

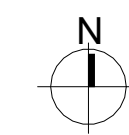

KEY PLAN 1:2000

NOTES:

PLEASE REFER TO MALONE O'REGAN CONSULTING ENGINEERS FOR ALL STRUCTURAL DRAWINGS AND DETAILS
 PLEASE REFER TO SEMPLE MCKILLOP CONSULTING ENGINEERS DRAWINGS FOR ALL MECHANICAL & ELECTRICAL DETAILS for the following:-
 - All proposed Mechanical Ventilation details
 - AOV's min clear opening 1.5m to specialist details
 - SVP drop locations & details
 - Electrical layout & Lift Services specification
 - Fire detection system specification & details throughout
 - Escape lighting specification & details & exit SIGNAGE

IMPORTANT NOTE:
 PLEASE REFER TO MITCHELL+ ASSOCIATES DRAWINGS/ REPORT FOR LANDSCAPING DETAILS

NOTE:
 As an alternative to the foregoing, products which satisfy the equivalent European standards in TDG Part B 2022 may be used.
 Allow for a 300x300mm access hatch in each apartment for hrv unit maintenance

NOTE 1:
 All pipes passing through fire resisting construction to be firestopped.
 Please read in conjunction with MCORM detail drawings and specifications.

Area Schedule (Apartment Area)		
Apartment Type	Area	Count
2 BED APARTMENT TYPE A-2B4P-1		
2 BED APARTMENT TYPE A-2B4P-1	78 m ²	17
2 BED APARTMENT TYPE A-2B4P-12		
2 BED APARTMENT TYPE A-2B4P-12	86 m ²	6

TOTAL: 23

NO. OF FLOORS: 6 STOREYS

GROUND FLOOR: BICYCLE STORES	: 25	SPACES
GROSS AREA	: 2 515m ²	RESIDENTIAL
NET AREA	: 1 842m ²	RESIDENTIAL

LEGEND	
* UNIT X	DUAL ASPECT UNIT
Xm ²	UNIT NUMBER
	UNIT AREA m ²
⬆	LEVEL HEIGHT
ST	STORAGE
- - -	OUTLINE OF STRUCTURE ABOVE

REV	DATE	DESCRIPTION	ISSUED BY
A	28/06/2024	General Updates	JH

FOR PLANNING

CLIENT: NDFA on behalf of South Dublin County Council
 PROJECT TITLE: Proposed Part 8 Residential Development Kishoge, Lucan

DRAWING TITLE: APARTMENT BLOCK A- THIRD FLOOR PLAN

DRN BY: JH	CHK BY: PMcN	SCALE @ A1: 1:100	DATE: 28/06/2024	REVISION: A	JOB NO: 23004
DRAWING NUMBER: SHB5-CSD-DR-MCORM-AR-P3-1104					STATUS CODE: P3

MCORM
 ARCHITECTURE AND URBAN DESIGN

No.1 Grantham Street, Dublin 8
 D08 A69Y Tel: +353 (0)1 478 8700
 Block 6, Central Business Park
 Tullamore, County Offaly
 R35 F9FB Tel: +353 (0)7 932 3867
 website: www.mcorm.com
 email: arch@mcorm.com

Figured dimensions only to be used. This drawing is copyright of MCORM Ltd. All information is shared as per approved use in accordance with I.S. 884:2011 to I.S. EN ISO 19550-2: 2018. If 'Status Code' above is empty, this information has been shared as Status Code S0 - Work in Progress (WIP) / Draft.