


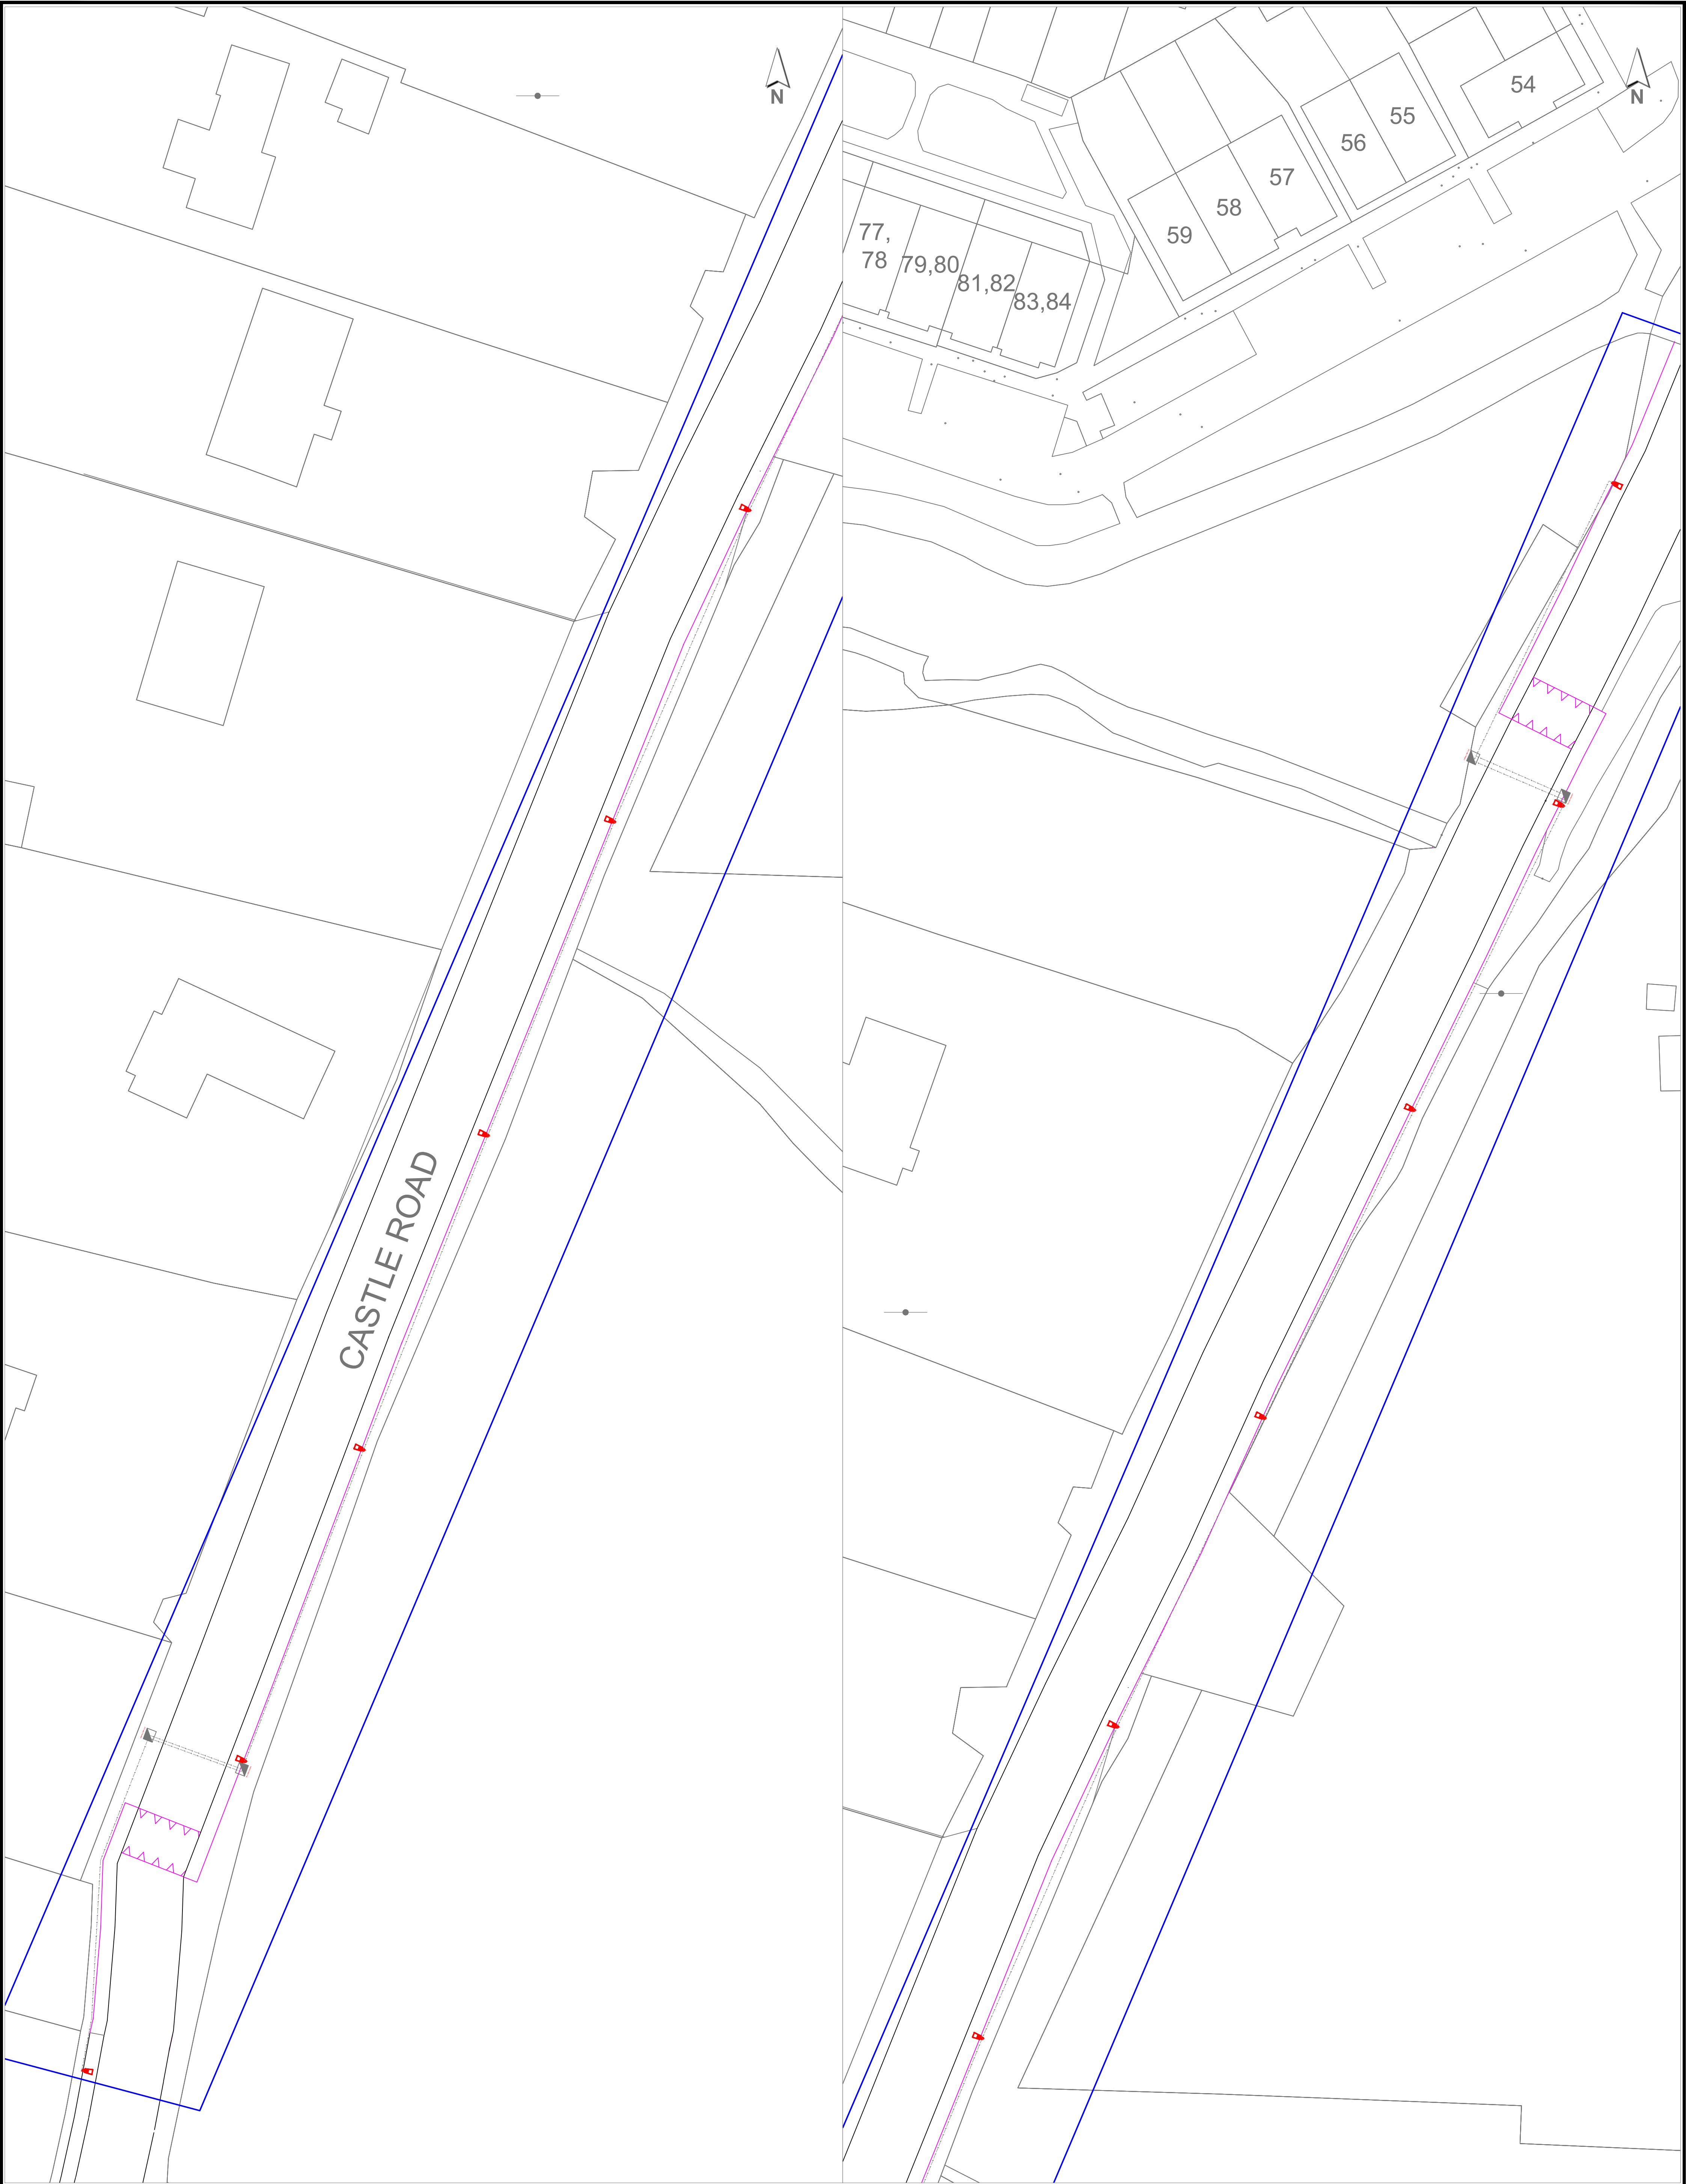

COMHAIRLE CHONTAE ÁTHA CLIATH THEAS
SOUTH DUBLIN COUNTY COUNCIL
PLANNING AND TRANSPORT

Comhairle Contae
Átha Cliath Theas
South Dublin
County Council

Includes Tailte Éireann data reproduced under Licence number CYAL50511400 South Dublin County Council. Unauthorised reproduction infringes Tailte Éireann and Government of Ireland copyright.
© Tailte Éireann - Surveying.

PROJECT Slade Road		DRAWING TITLE Proposed Lighting Layout	JOB NO 202607
DRAWING NO. Illustration Purposes only	DATE 25/06/26	SENIOR ENGINEER Gary Walsh	SURVEYED BY R.McC
D.S. SHEET NO. 3451-B	SCALE 1:300 @ A1	DIRECTOR Eoin Burke	DRAWN BY T.S