


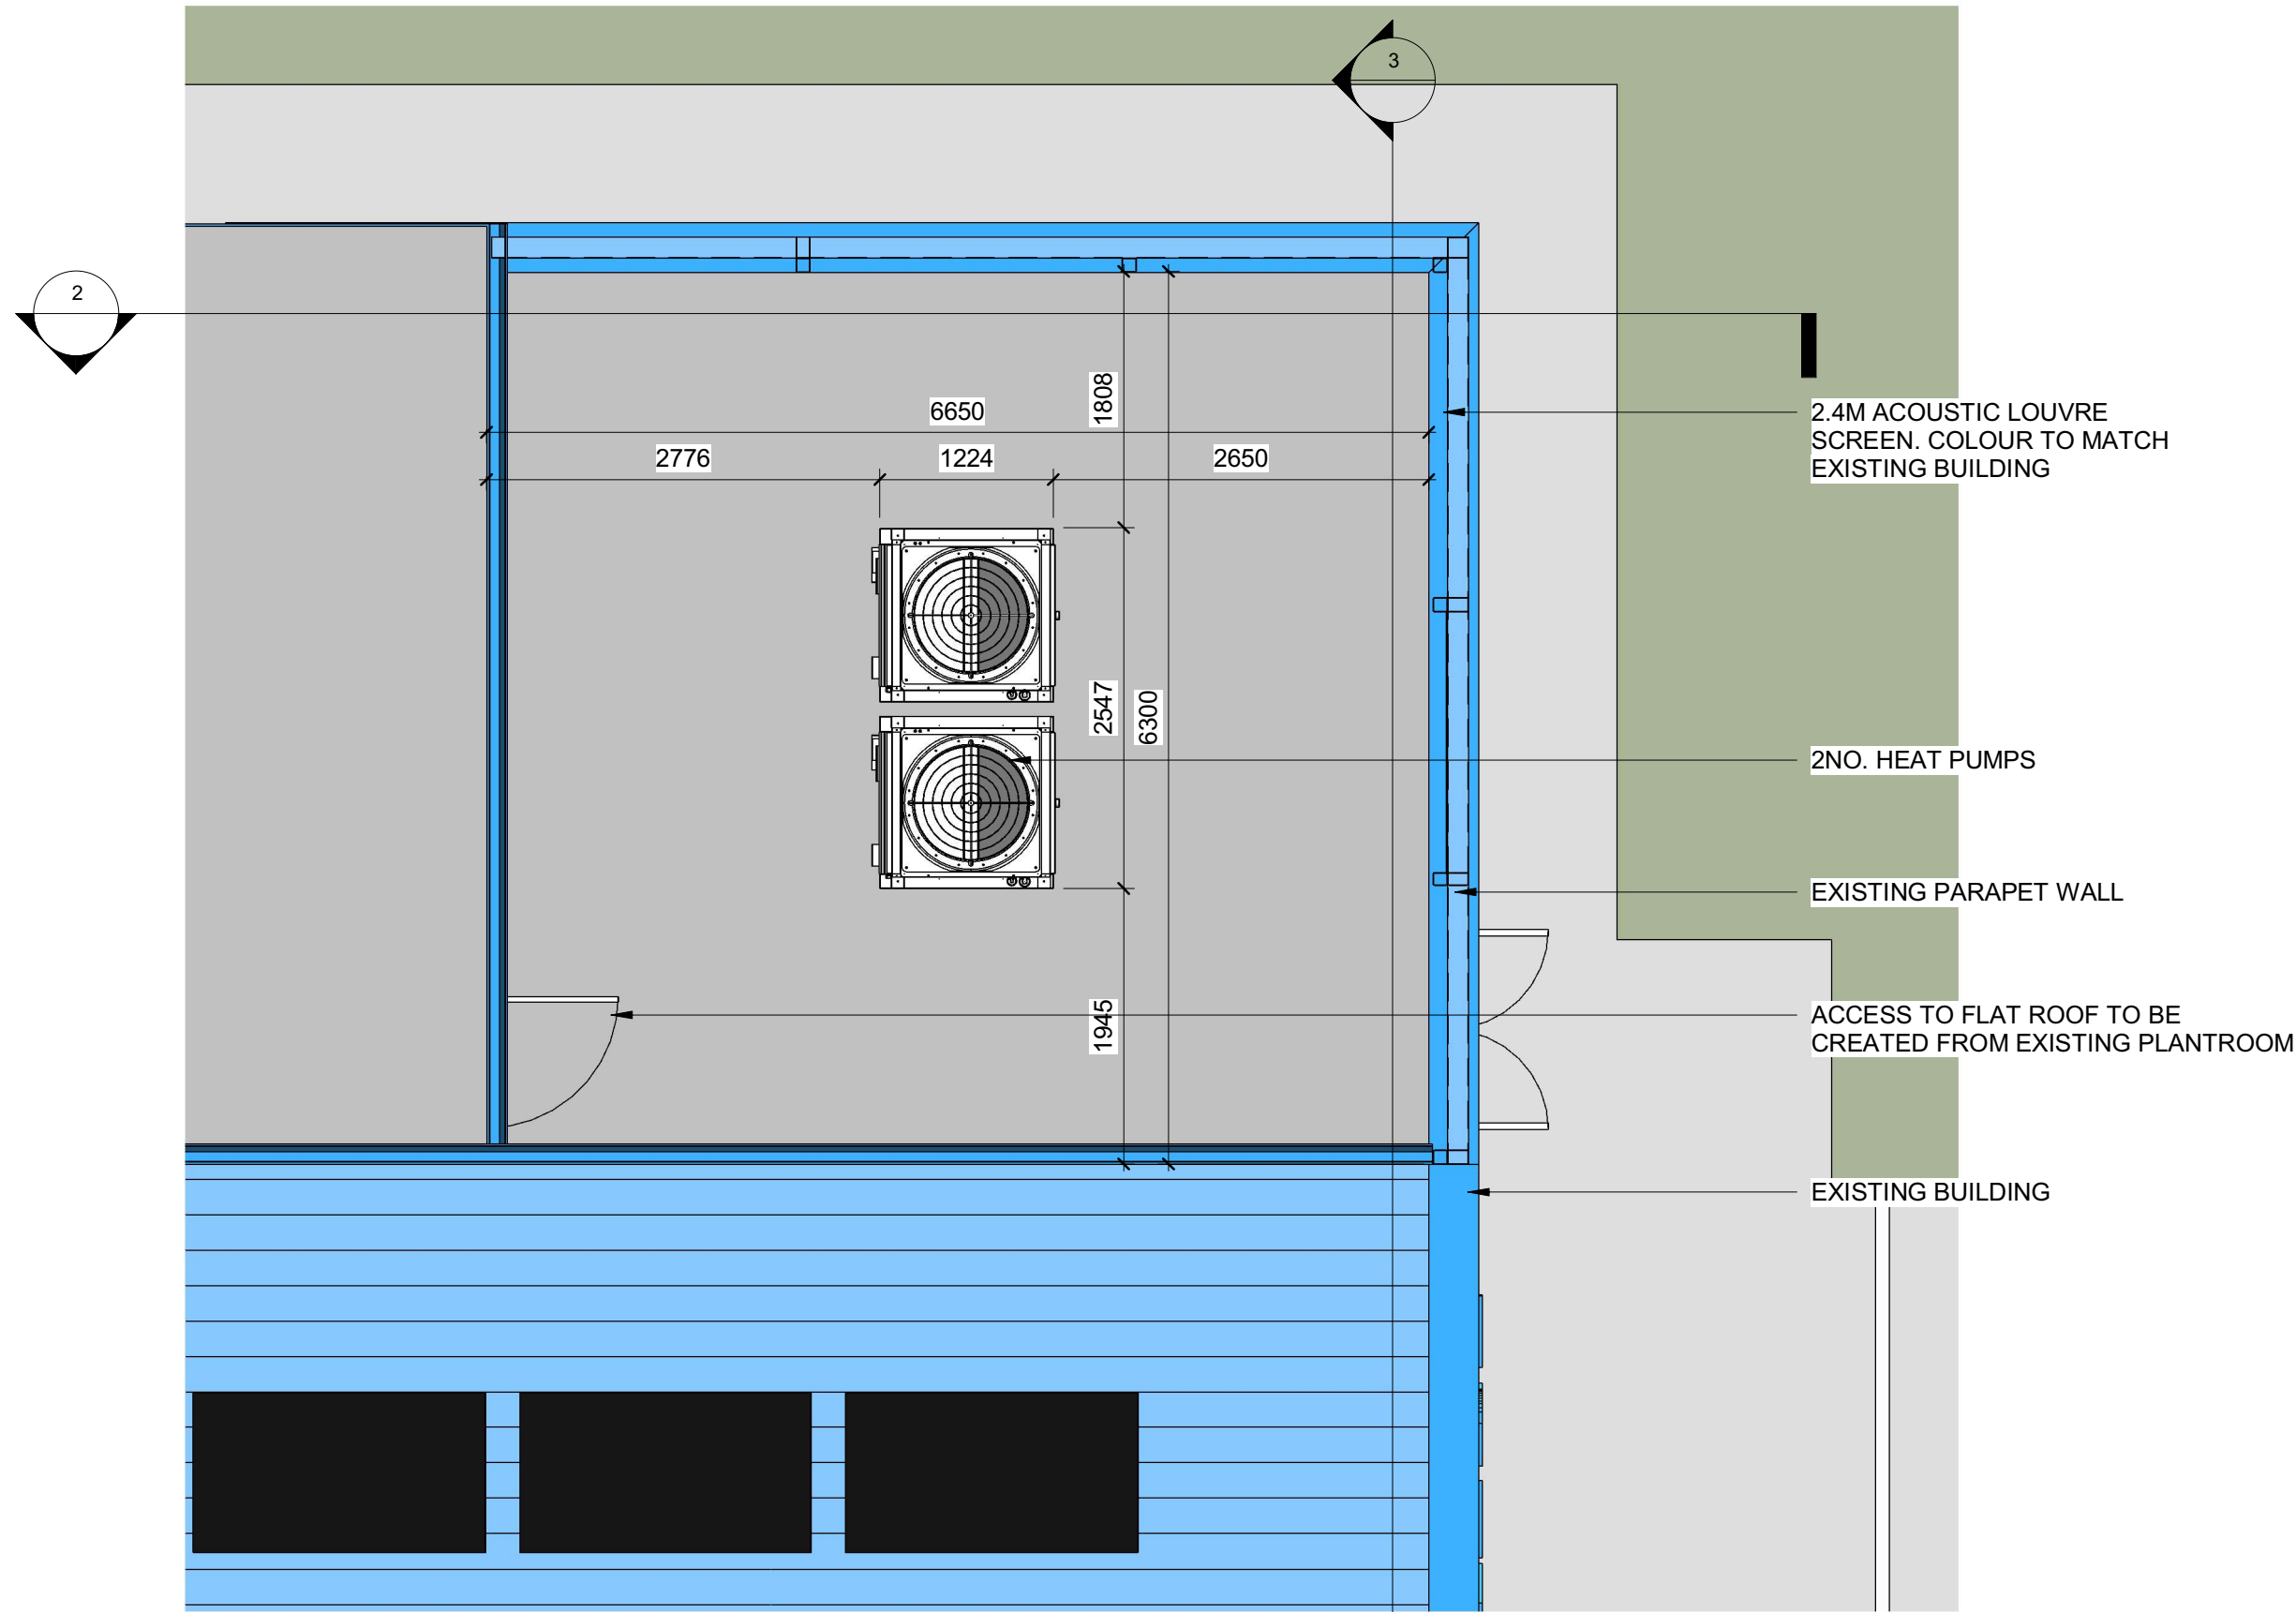


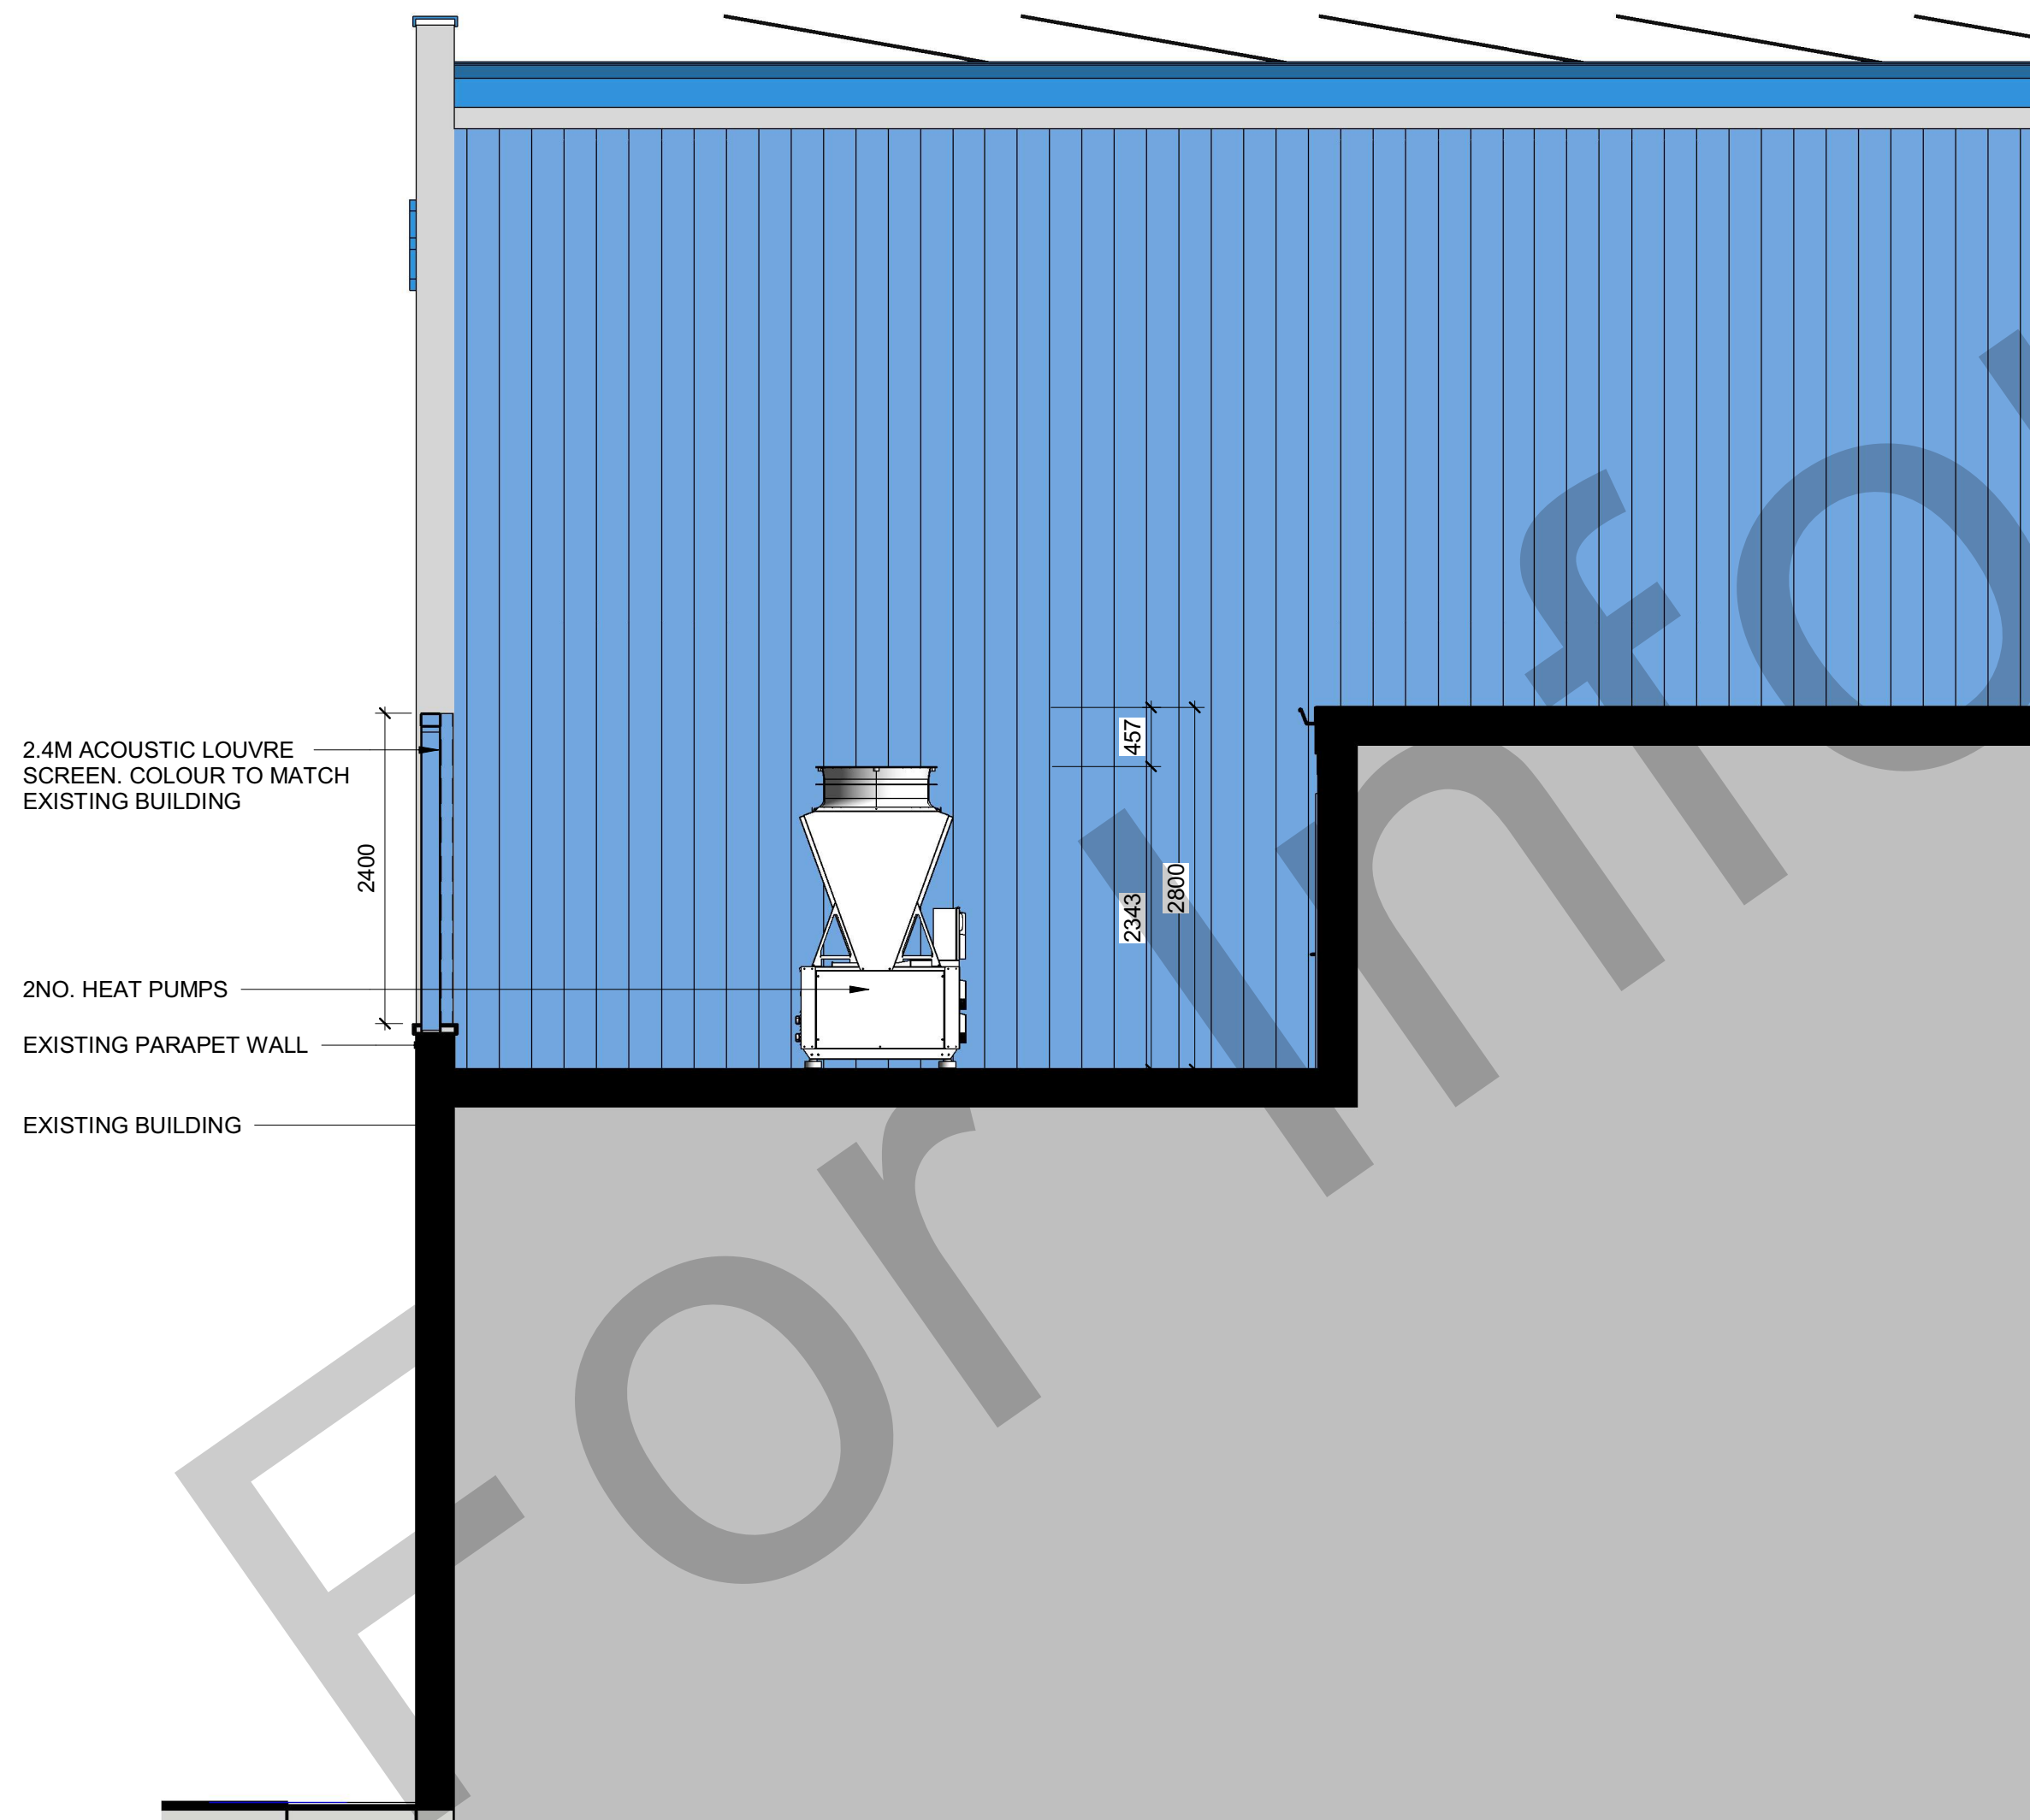

Civic Theatre - Site Plan (Detailed)
1 : 50

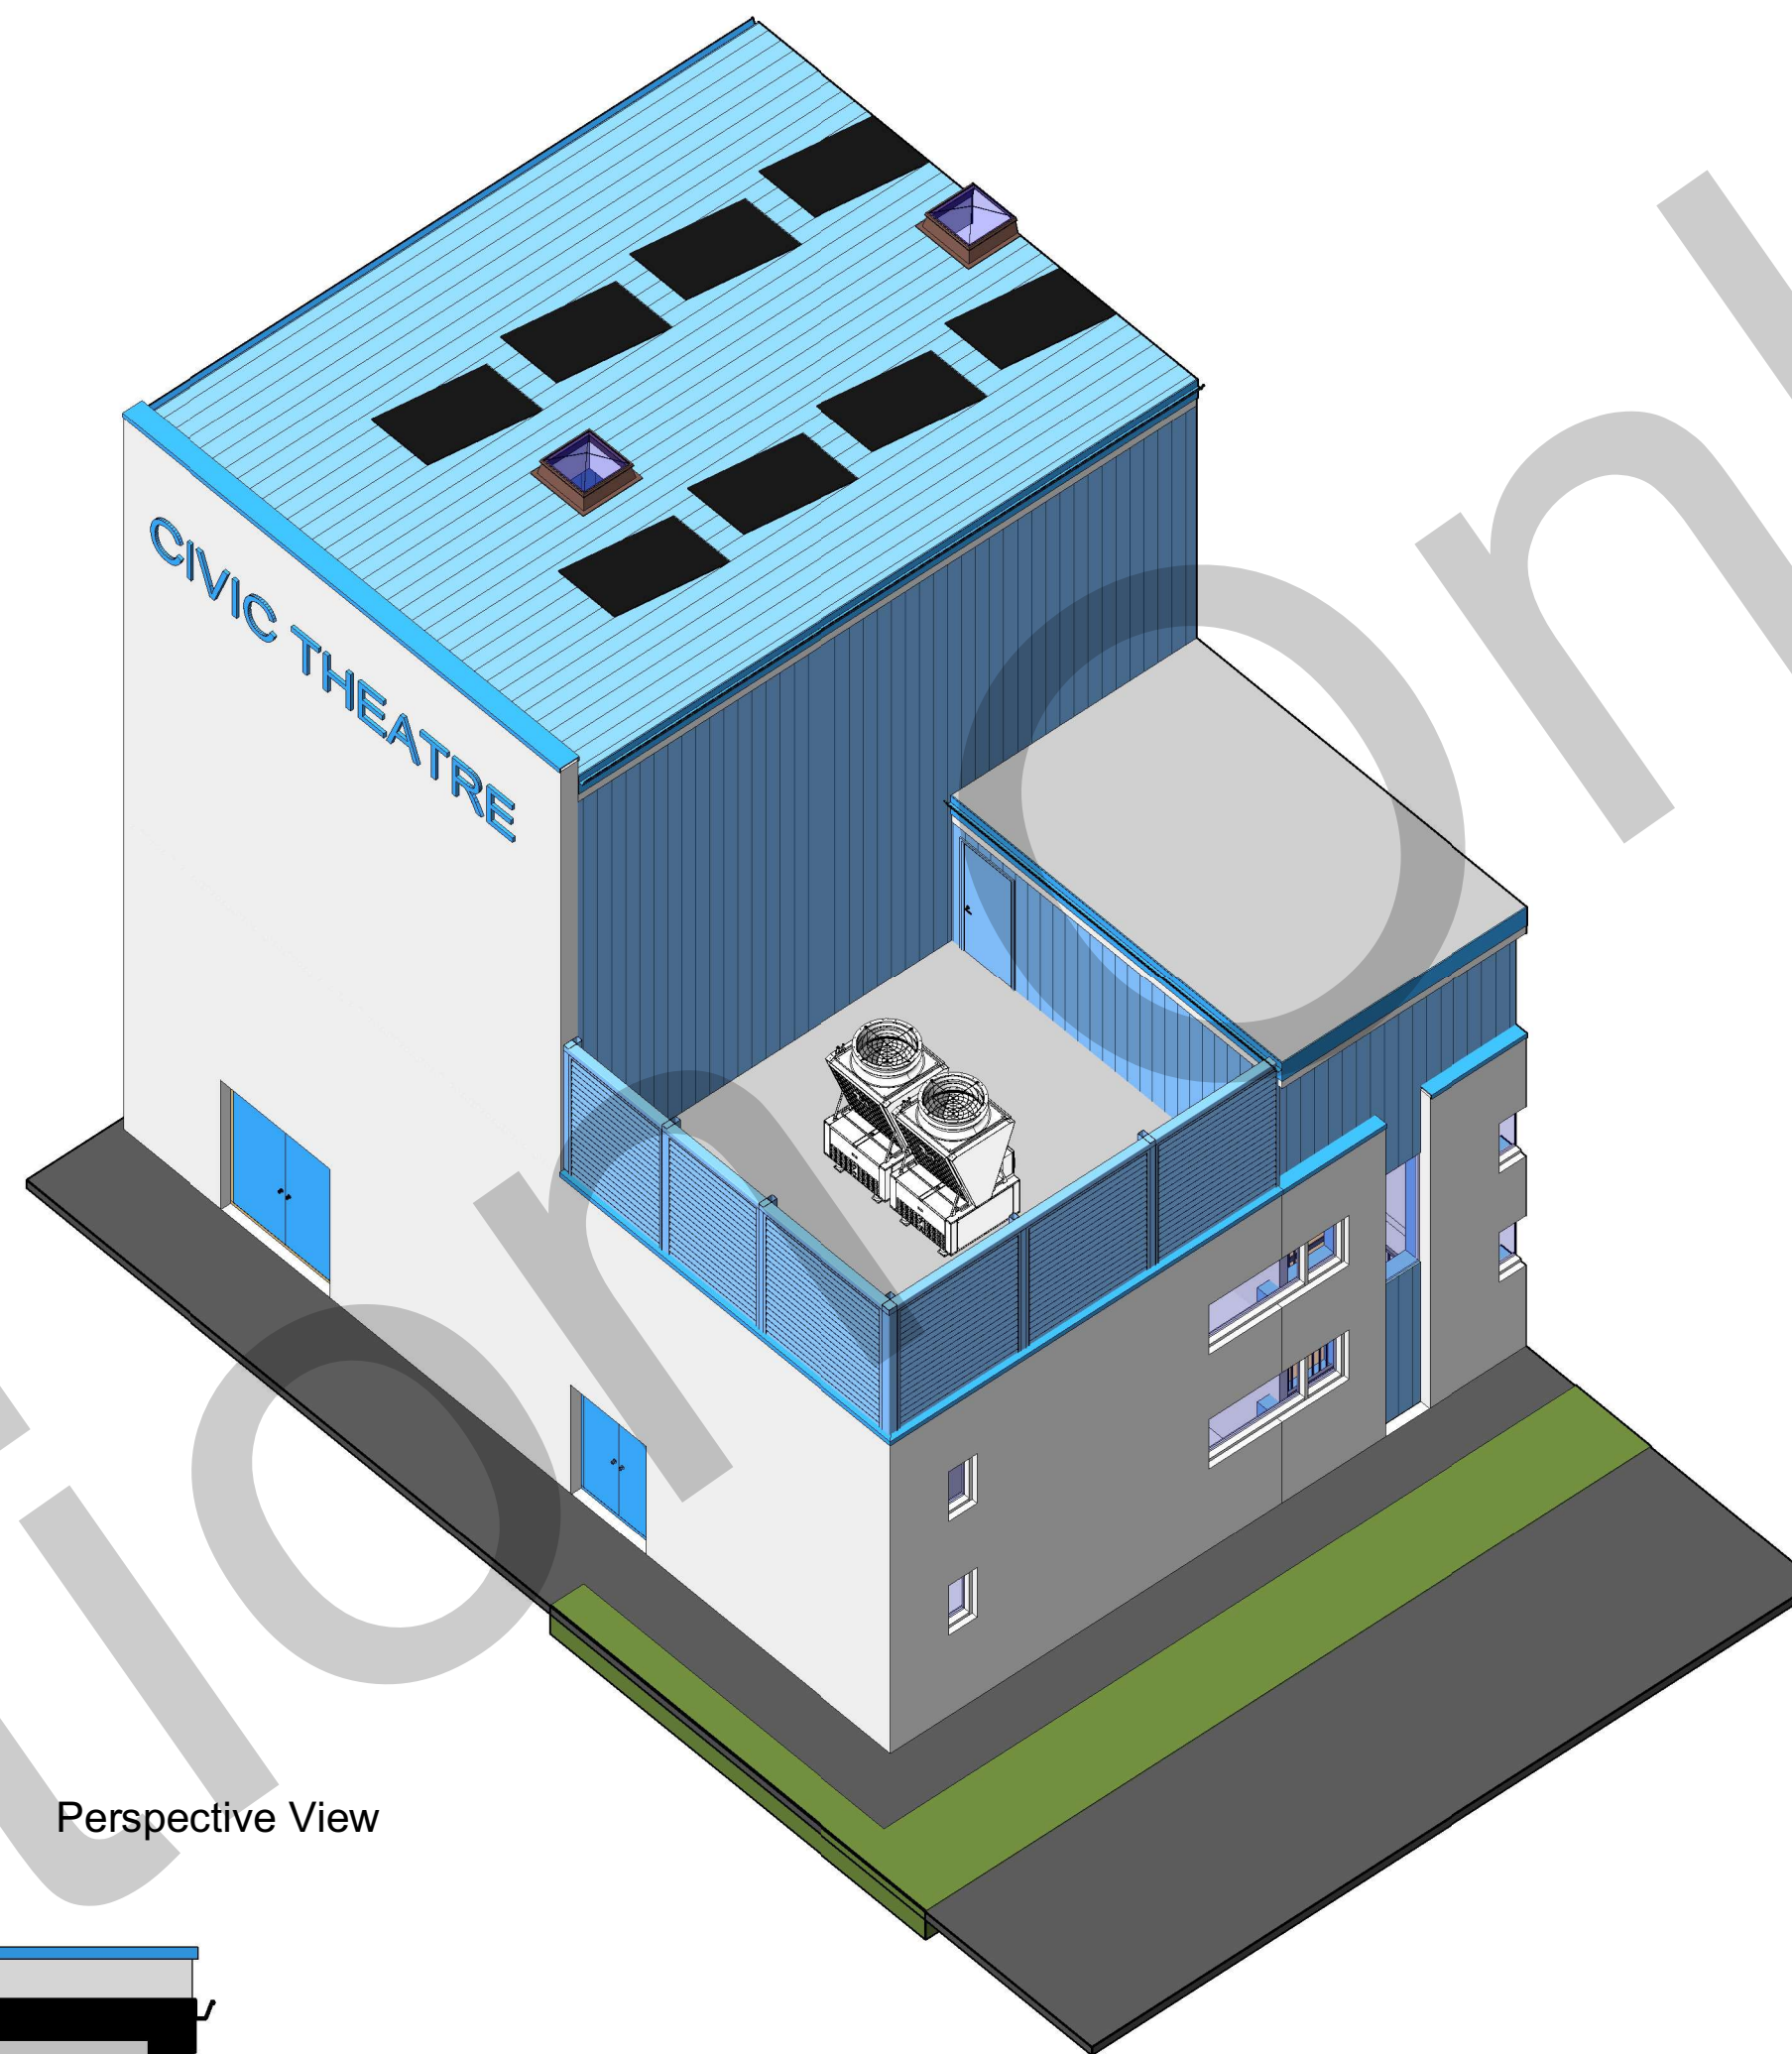

Civic Theatre - Section 01
1 : 50

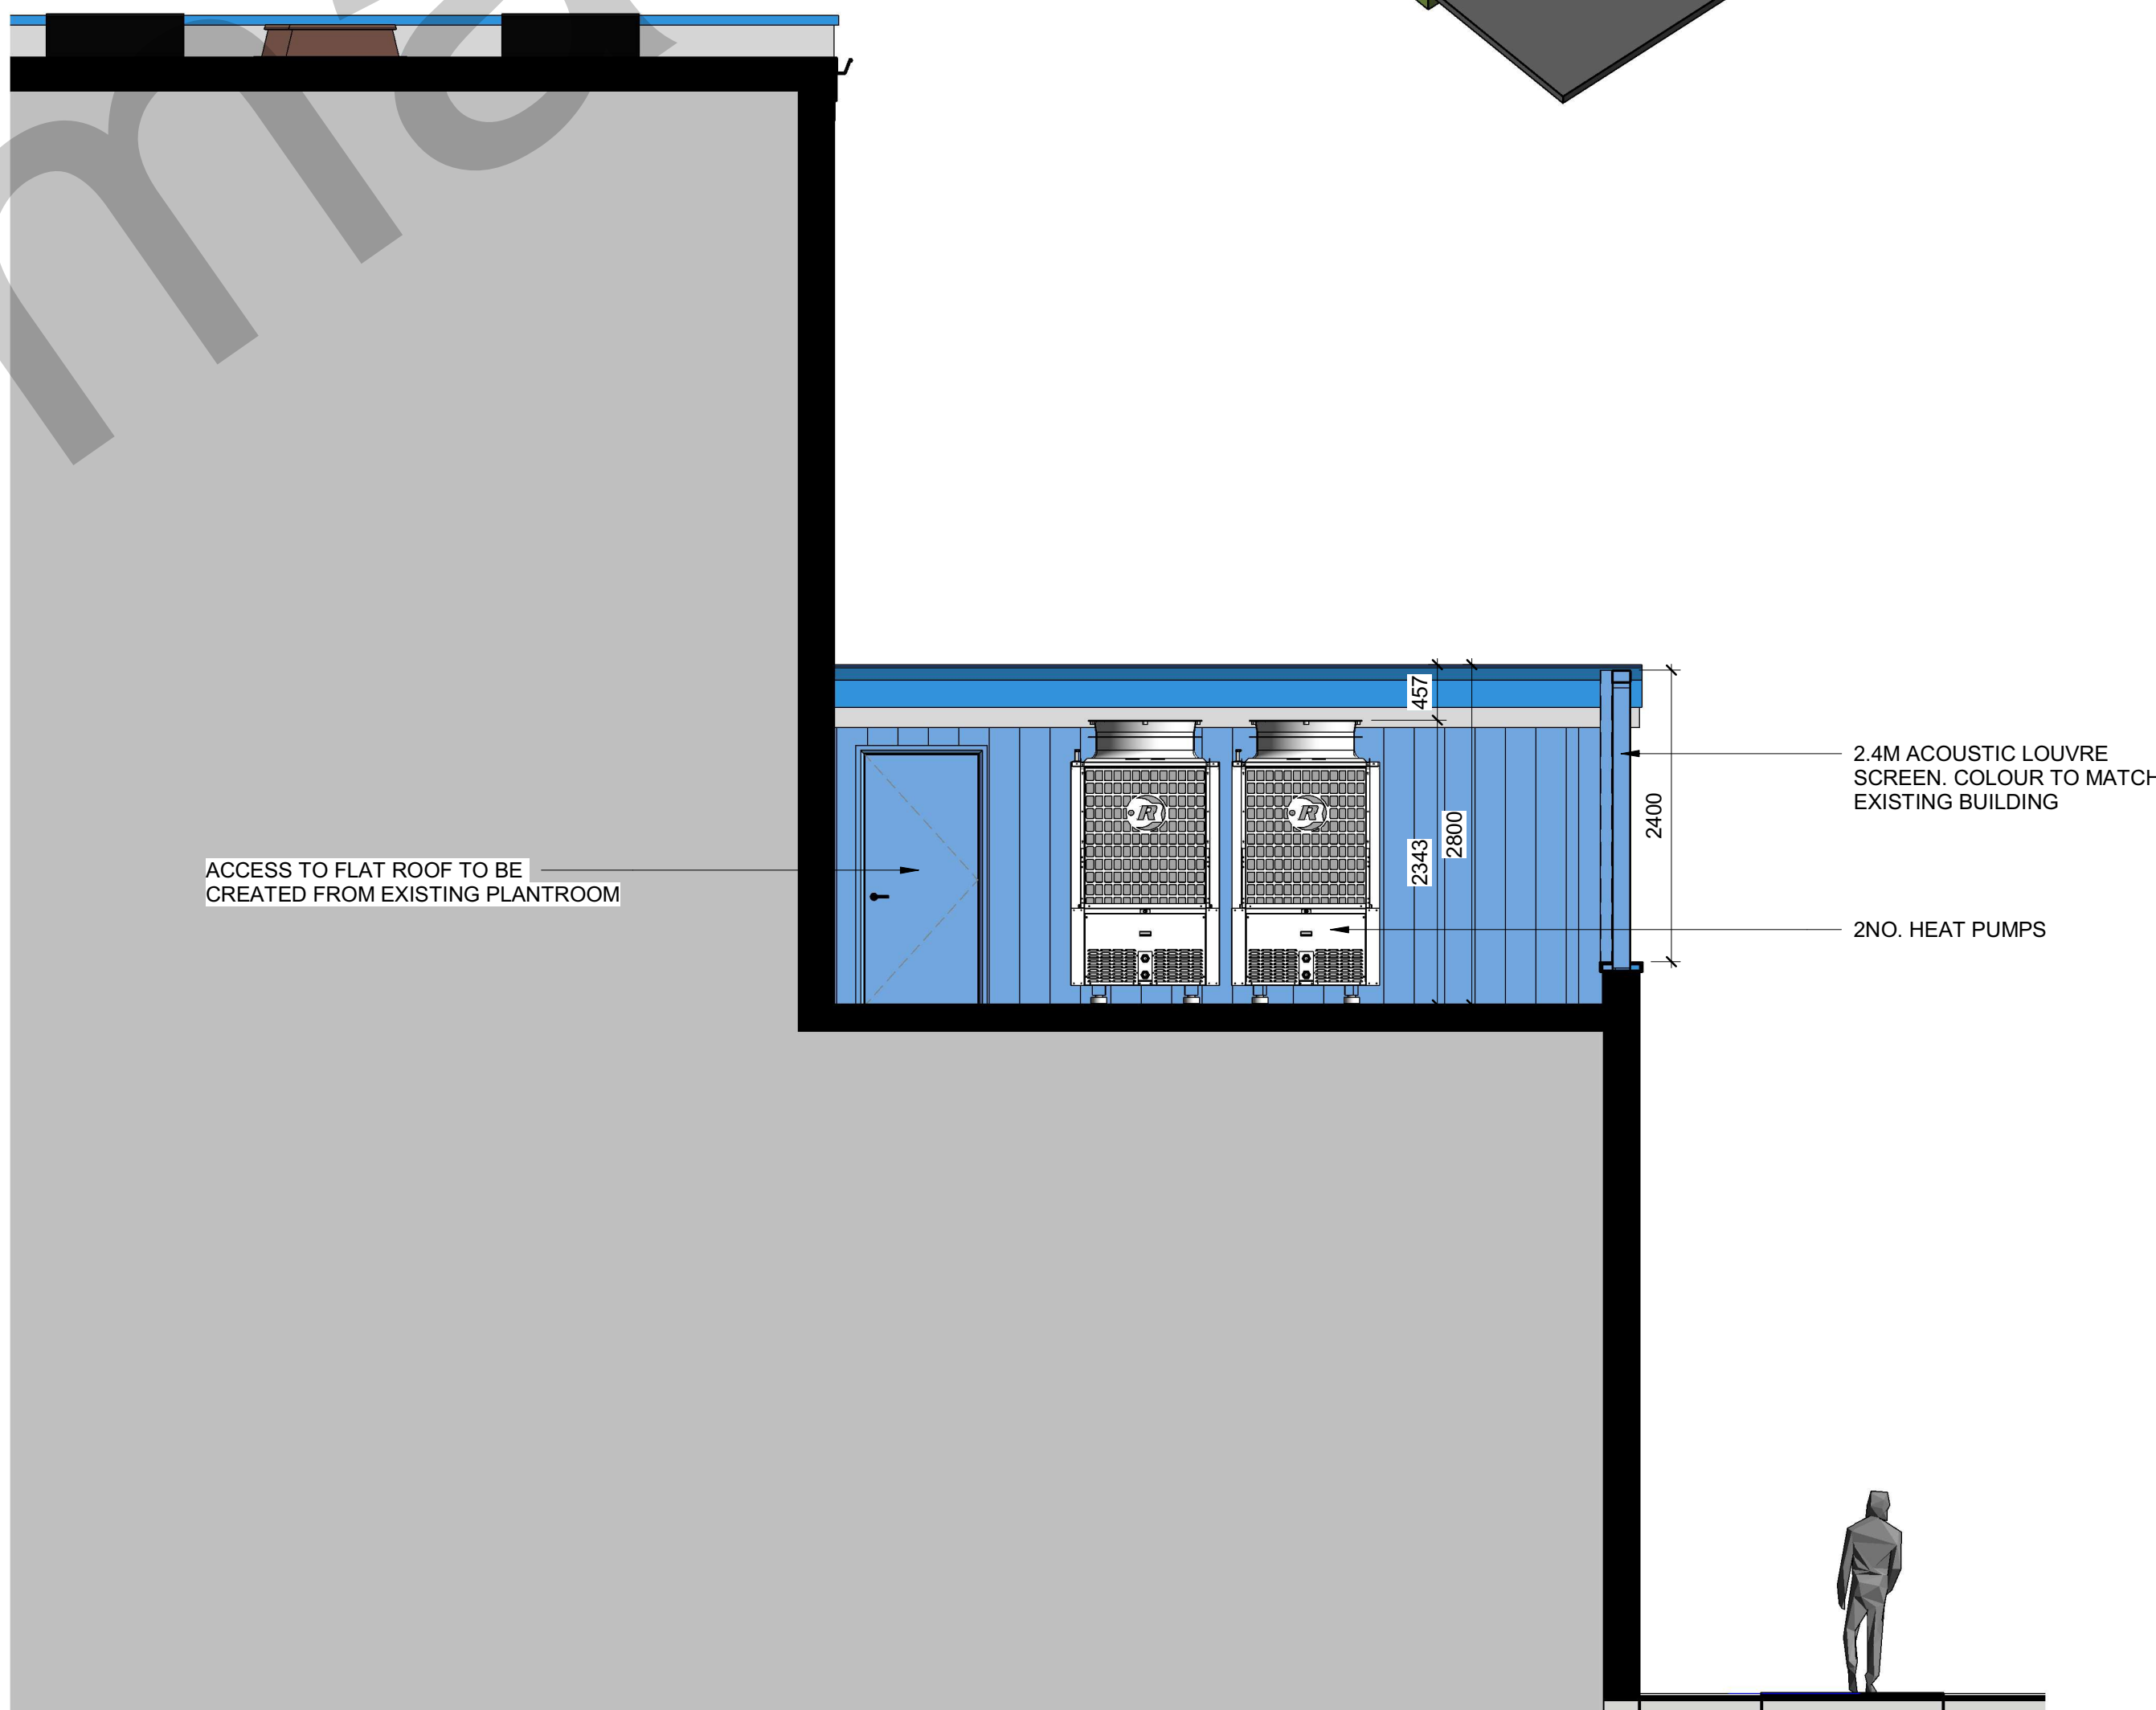

Civic Theatre - Section 02
1 : 50

Disclaimer:
This drawing is the property of Alternative Heat © to be used only in this project, unless contractually otherwise stated, which purpose is for spatial co-ordination, and it has been prepared from historical information of external consultants, so it cannot be guaranteed accurate, therefore it must not be scaled either in printed or electronic versions, and reference must be made to the individual consultant information for exact figured dimensions & co-ordination, and any discrepancies/ambiguities within this drawing and information provided elsewhere, must be reported immediately to Alternative Heat for clarification prior the manufacture of any components and on-site installation/constructing/selling-out, which works unless specifically directed otherwise in the specification are to be carried out in accordance with the latest British standards and codes of practice, and all contractors are responsible to check all information prior carrying the works.

Notes:
1. For insulation specification refer to technical submittal.
2. All Dimensions are in millimetres unless otherwise noted.
3. All invert levels are given to centre of pipe.
4. All invert levels are taken from SS.F.F.L +0.00mm.
5. All pipe DN65-300 to be material Spec - F235GH welded to EN10253-2.
6. All pipe DN15-50 to be material Spec - ST195T, threaded to EN10242.
7. All external pipe to be trace heated and aluminium clad.
8. All external valves to be fully weather-proofed.

Rev	Date	Revision Notes	JR	CF
P01	05/05/26	FIRST ISSUE	JR	CF

Client: Comhairle Contae
Alpha Clutha Theas
South Dublin County Council

alternativeHEAT
Commercial Energy Solutions

T: +44 (0) 28 4377 0100
E: info@alternativeheat.co.uk
Unit 25A, Scarra road Industrial Estate, Banbridge, BT32 3DD

Project: SOUTH DUBLIN COUNTY COUNCIL

Drawing Title: Civic Theatre - ASHP Compound General Arrangement Plan

Project Status: PLANNING	Project Revision: P01
Scale: 1: 50	Original Date: 05/05/26
Drawn: JR	Checked: CF

Drawing Number: SDC2401-ALT-CTH-XX-PL-U-00002