





Rua Red Art Centre- Site Plan
1 : 250

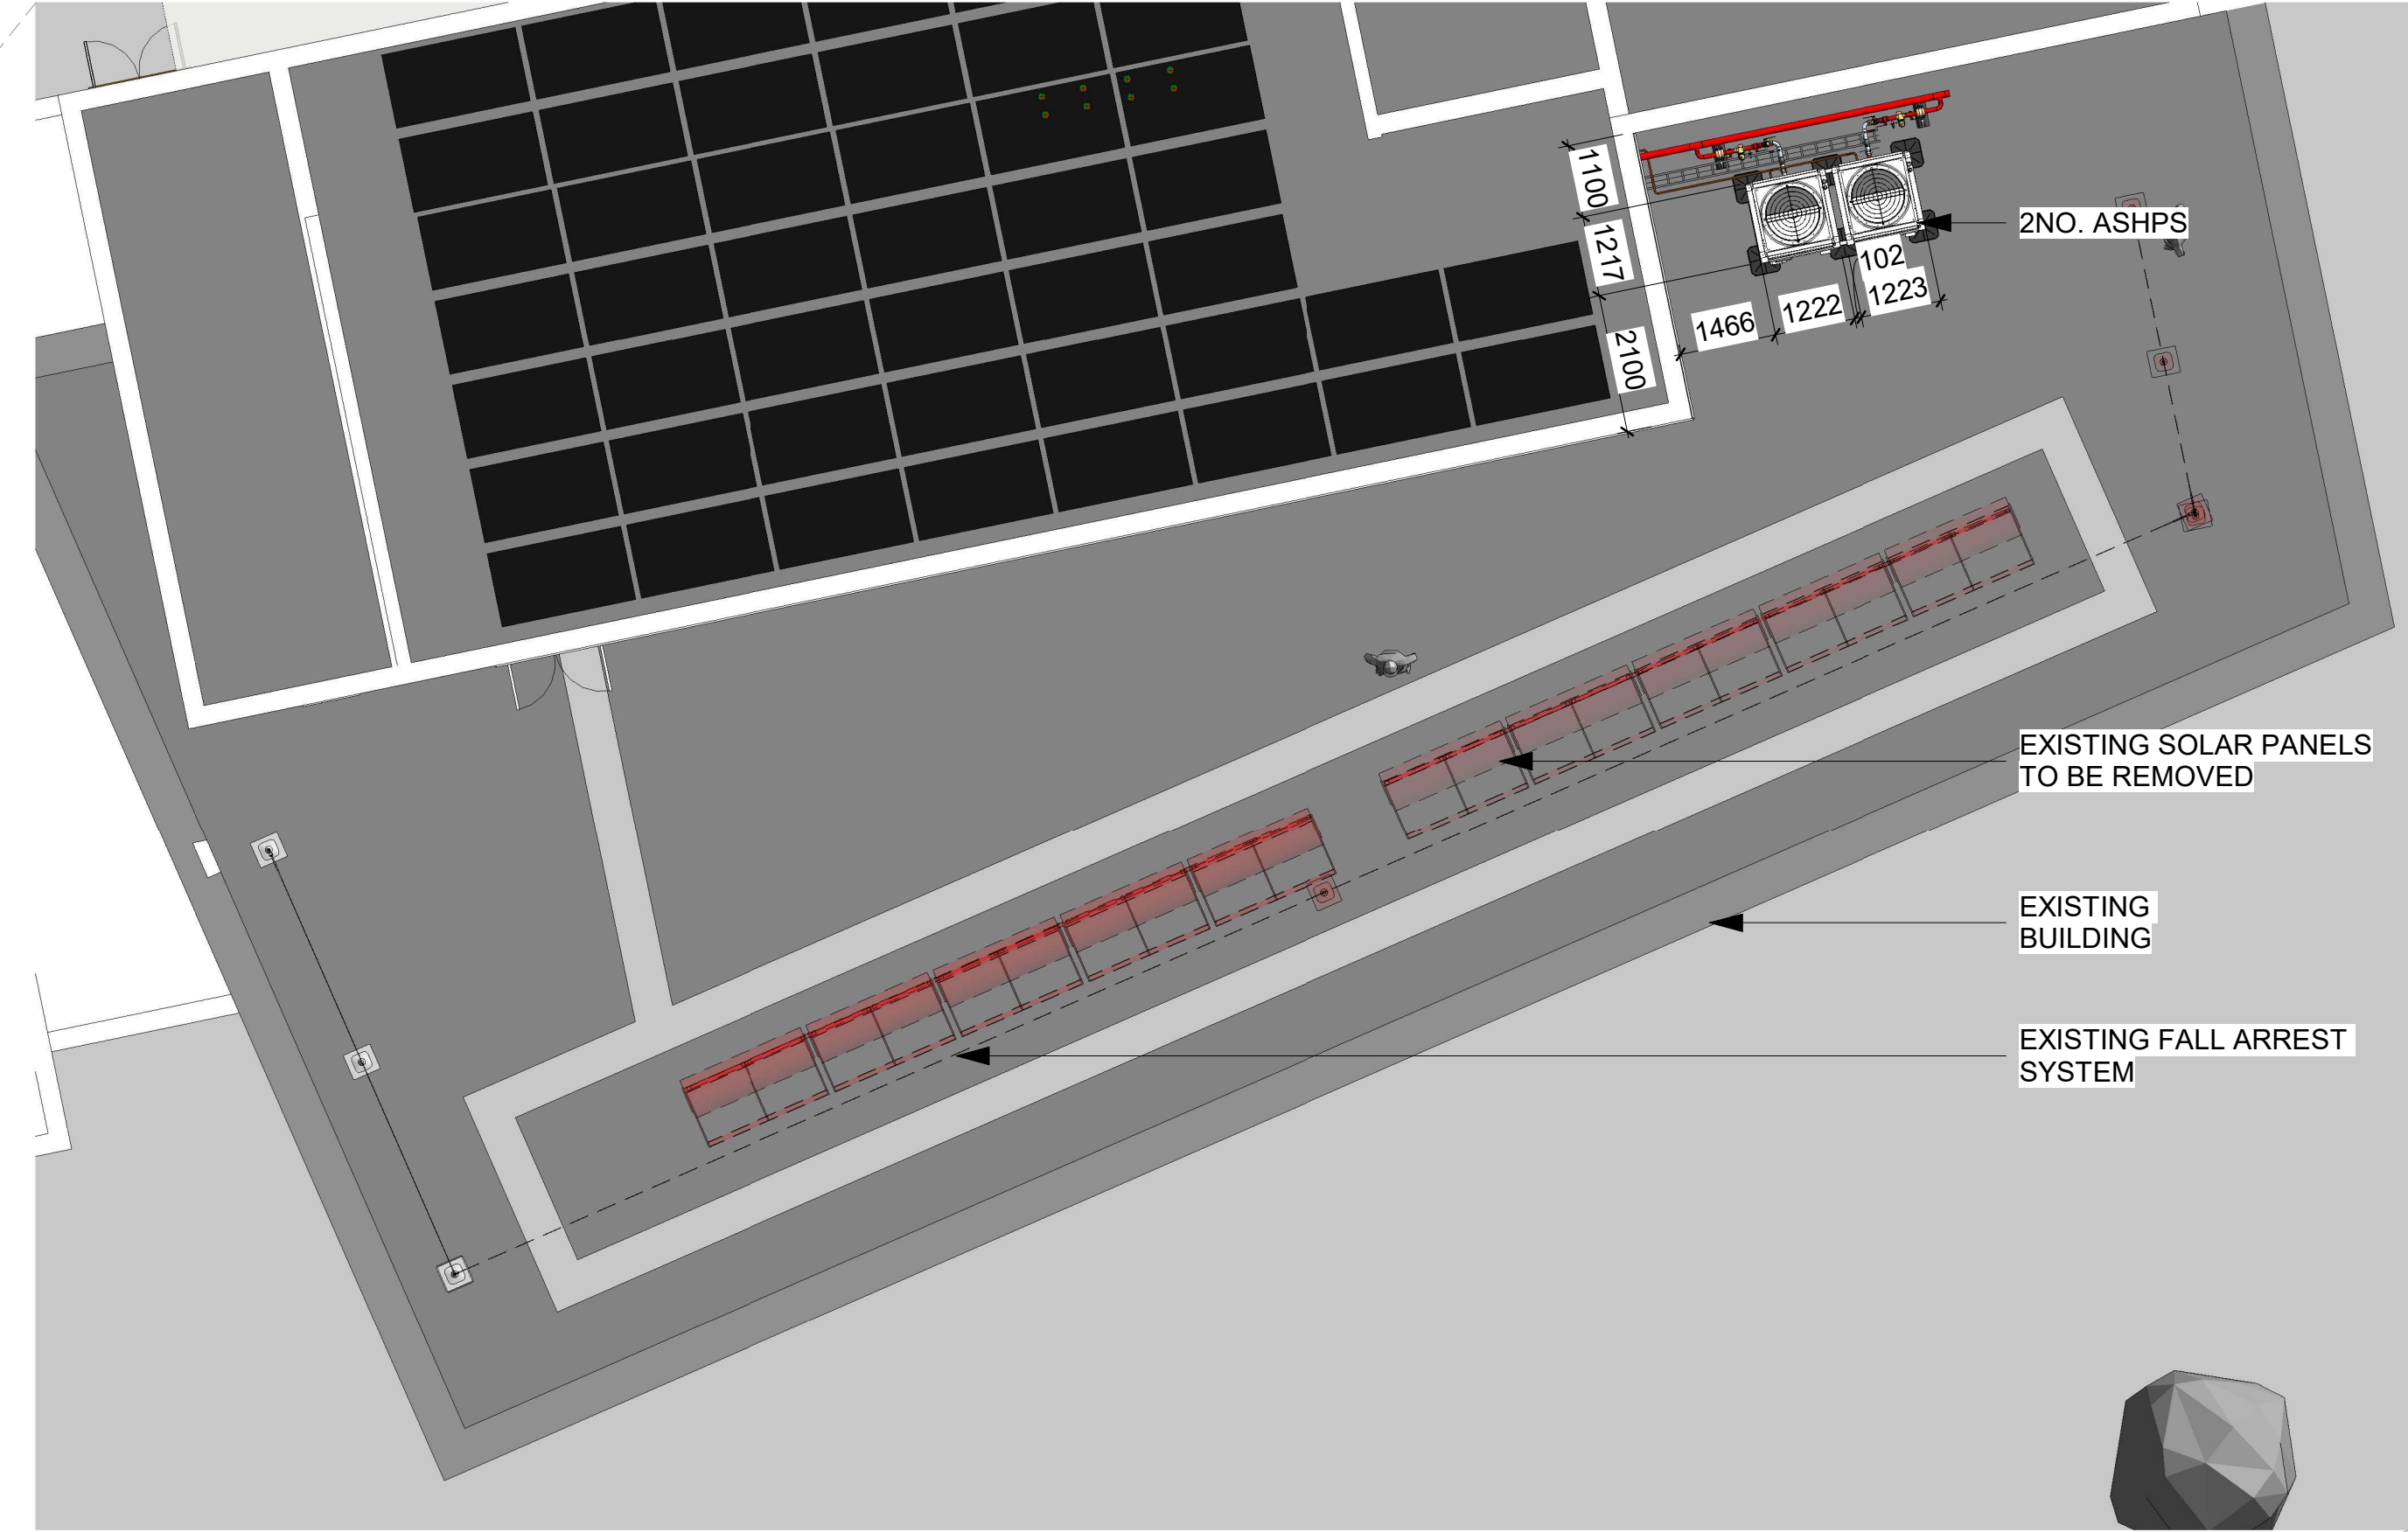

Rua Red Art Centre- Site Plan (Detailed)
1 : 100

Solar PV Details are shown for information only and are not part of the Part 8 Application

Rua Red Art Centre - 3D Perspective

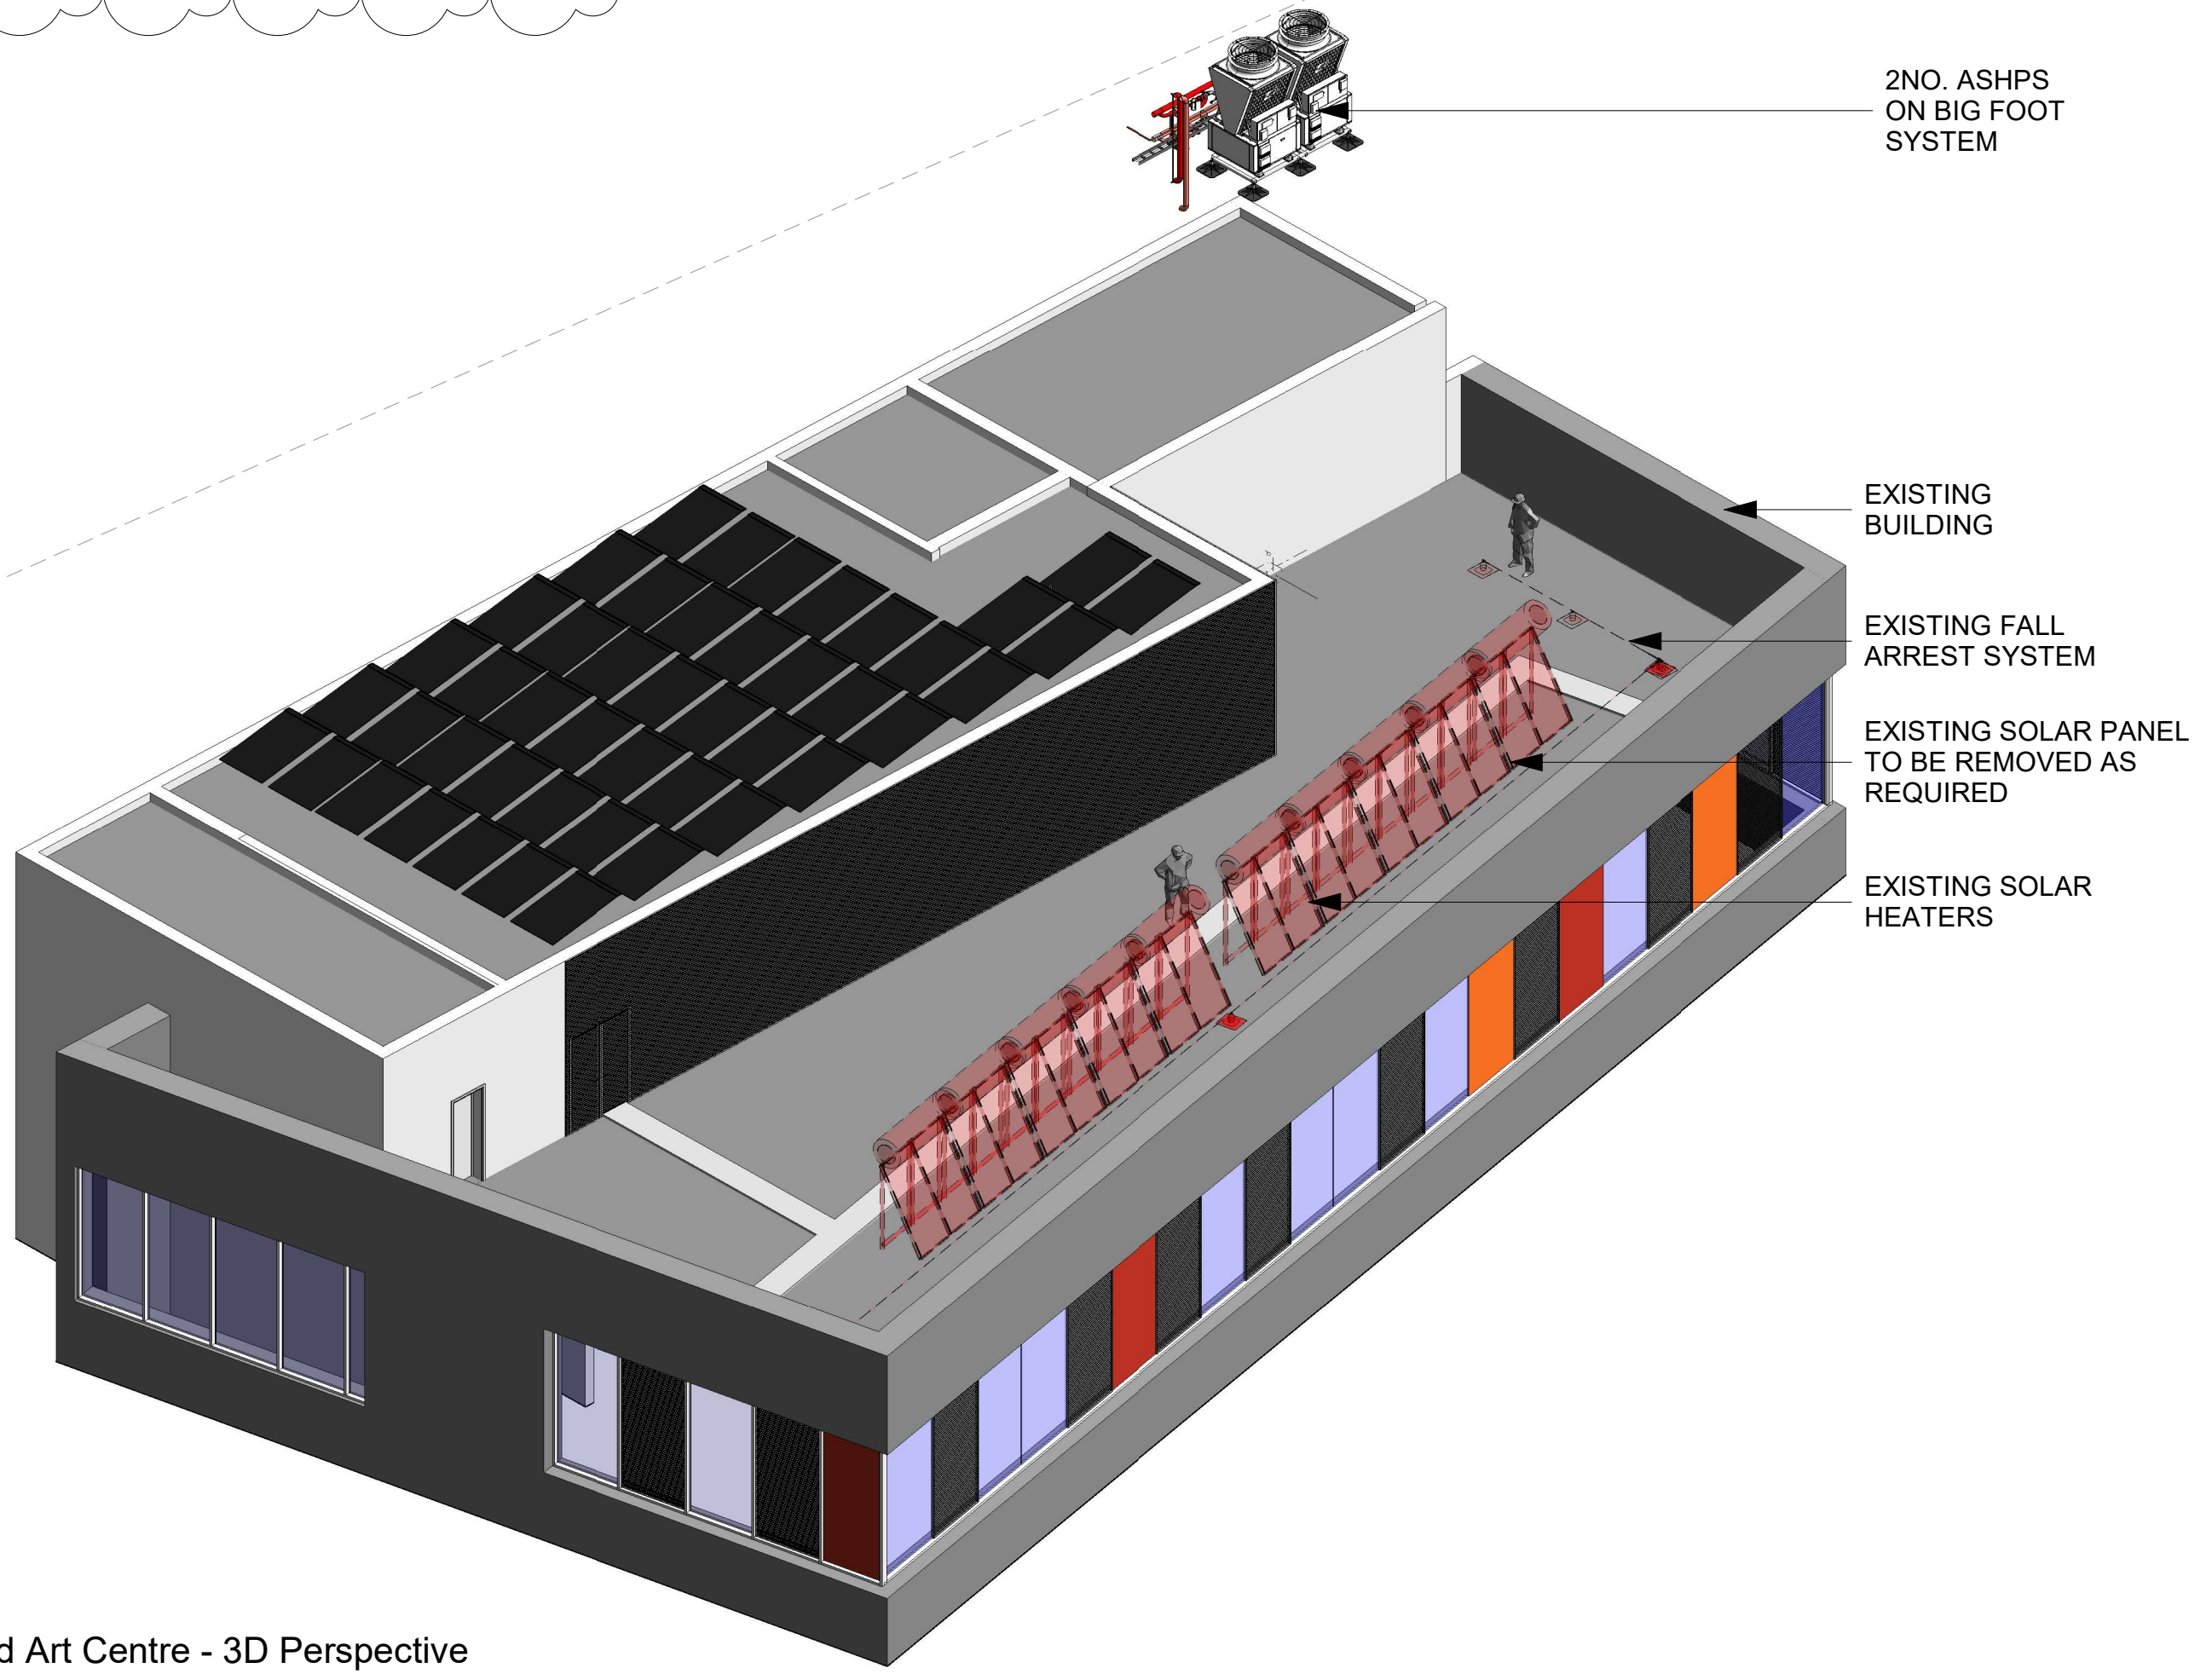

Disclaimer:
This drawing is the property of Alternative Heat © to be used only in this project, unless contractually otherwise stated, which purpose is for spatial coordination, and it has been prepared from historical information of external consultants, so it cannot be guaranteed accurate, therefore it must not be scaled either in printed or electronic versions, and reference must be made to the individual consultant information for exact figured dimensions & co-ordination, and any discrepancies/ambiguities within this drawing and information provided elsewhere, must be reported immediately to Alternative Heat for clarification prior the manufacture of any components and on-site installation/constructing/setting out, which works unless specifically directed otherwise in the specification are to be carried out in accordance with the latest British standards and codes of practice, and all contractors are responsible to check all information prior carrying the works.

Notes:
1. For insulation specification refer to technical submittal.
2. All Dimensions are in millimetres unless otherwise noted.
3. All invert levels are given to centre of pipe.
4. All invert levels are taken from SSI.FFL +0.00mm.
5. All pipe DN65-300 to be material Spec - P230GH, welded to EN10253-2.
6. All pipe DN15-50 to be material Spec - ST195T, threaded to EN10242.
7. All external pipe to be trace heated and aluminium clad.
8. All external valves to be fully weather-proofed.

- PROPOSED ASHP ENCLOSURE LOCATION
- BUILDING OUTLINE WITHIN SCOPE
- EXISTING PLANTROOM
- INCOMING ELECTRICAL SUPPLY
- POTENTIAL PV ARRAY LOCATIONS
- ABOVE GROUND SERVICES
- UNDERGROUND SERVICES TRENCH
- ABOVE GROUND ELECTRICAL SUPPLY
- UNDERGROUND ELECTRICAL SUPPLY
- SITE BOUNDARY
- FLAT ROOF
- PITCHED ROOF

P02	16/07/26	Note added & existing note updated on drawing as requested by SDC.	JR	CF
P01	05/05/26	FIRST ISSUE	JR	CF
Rev	Date	Revision Notes	Drw	Chk
SDCC				
alternativeHEAT				
Commercial Energy Solutions				
T: +44 (0) 28 4377 0700				
E: info@alternativeheat.co.uk				
Unit 15A, Scarra road Industrial Estate, Banbridge, BT32 3QD				
Project SOUTH DUBLIN COUNTY COUNCIL				
Drawing Title Rua Red - Site Plan				
Project Status			Project Revision	
PLANNING			P02	
Scale/As Indicated	Original Date	Drawn	Checked	
As Indicated	05/05/26	JR	CF	
Drawing Number SDC2401-ALT-RAC-XX-PL-U-00001				