



Disclaimer:
This drawing is the property of Alternative Heat © to be used only in this project, unless contractually otherwise stated, which purpose is for spatial co-ordination, and it has been prepared from historical information of external consultants, so it cannot be guaranteed accurate, therefore it must not be scaled either in printed or electronic versions, and reference must be made to the individual consultant information for exact figured dimensions & co-ordination, and any discrepancies/ambiguities within this drawing and information provided elsewhere, must be reported immediately to Alternative Heat for clarification prior the manufacture of any components and on-site installation/constructing/selling-out, which works unless specifically directed otherwise in the specification are to be carried out in accordance with the latest British standards and codes of practice, and all contractors are responsible to check all information prior carrying the works.


Notes:
1. For insulation specification refer to technical submittal.
2. All dimensions are in millimetres unless otherwise noted.
3. All invert levels are given to centre of pipe.
4. All invert levels are taken from SSI.FFL +0.00mm.
5. All pipe DN65-300 to be material Spec - P235GH welded to EN10253-2.
6. All pipe DN15-50 to be material Spec - ST195T, threaded to EN10242.
7. All external pipe to be trace heated and aluminium clad.
8. All external valves to be fully weather-proofed.

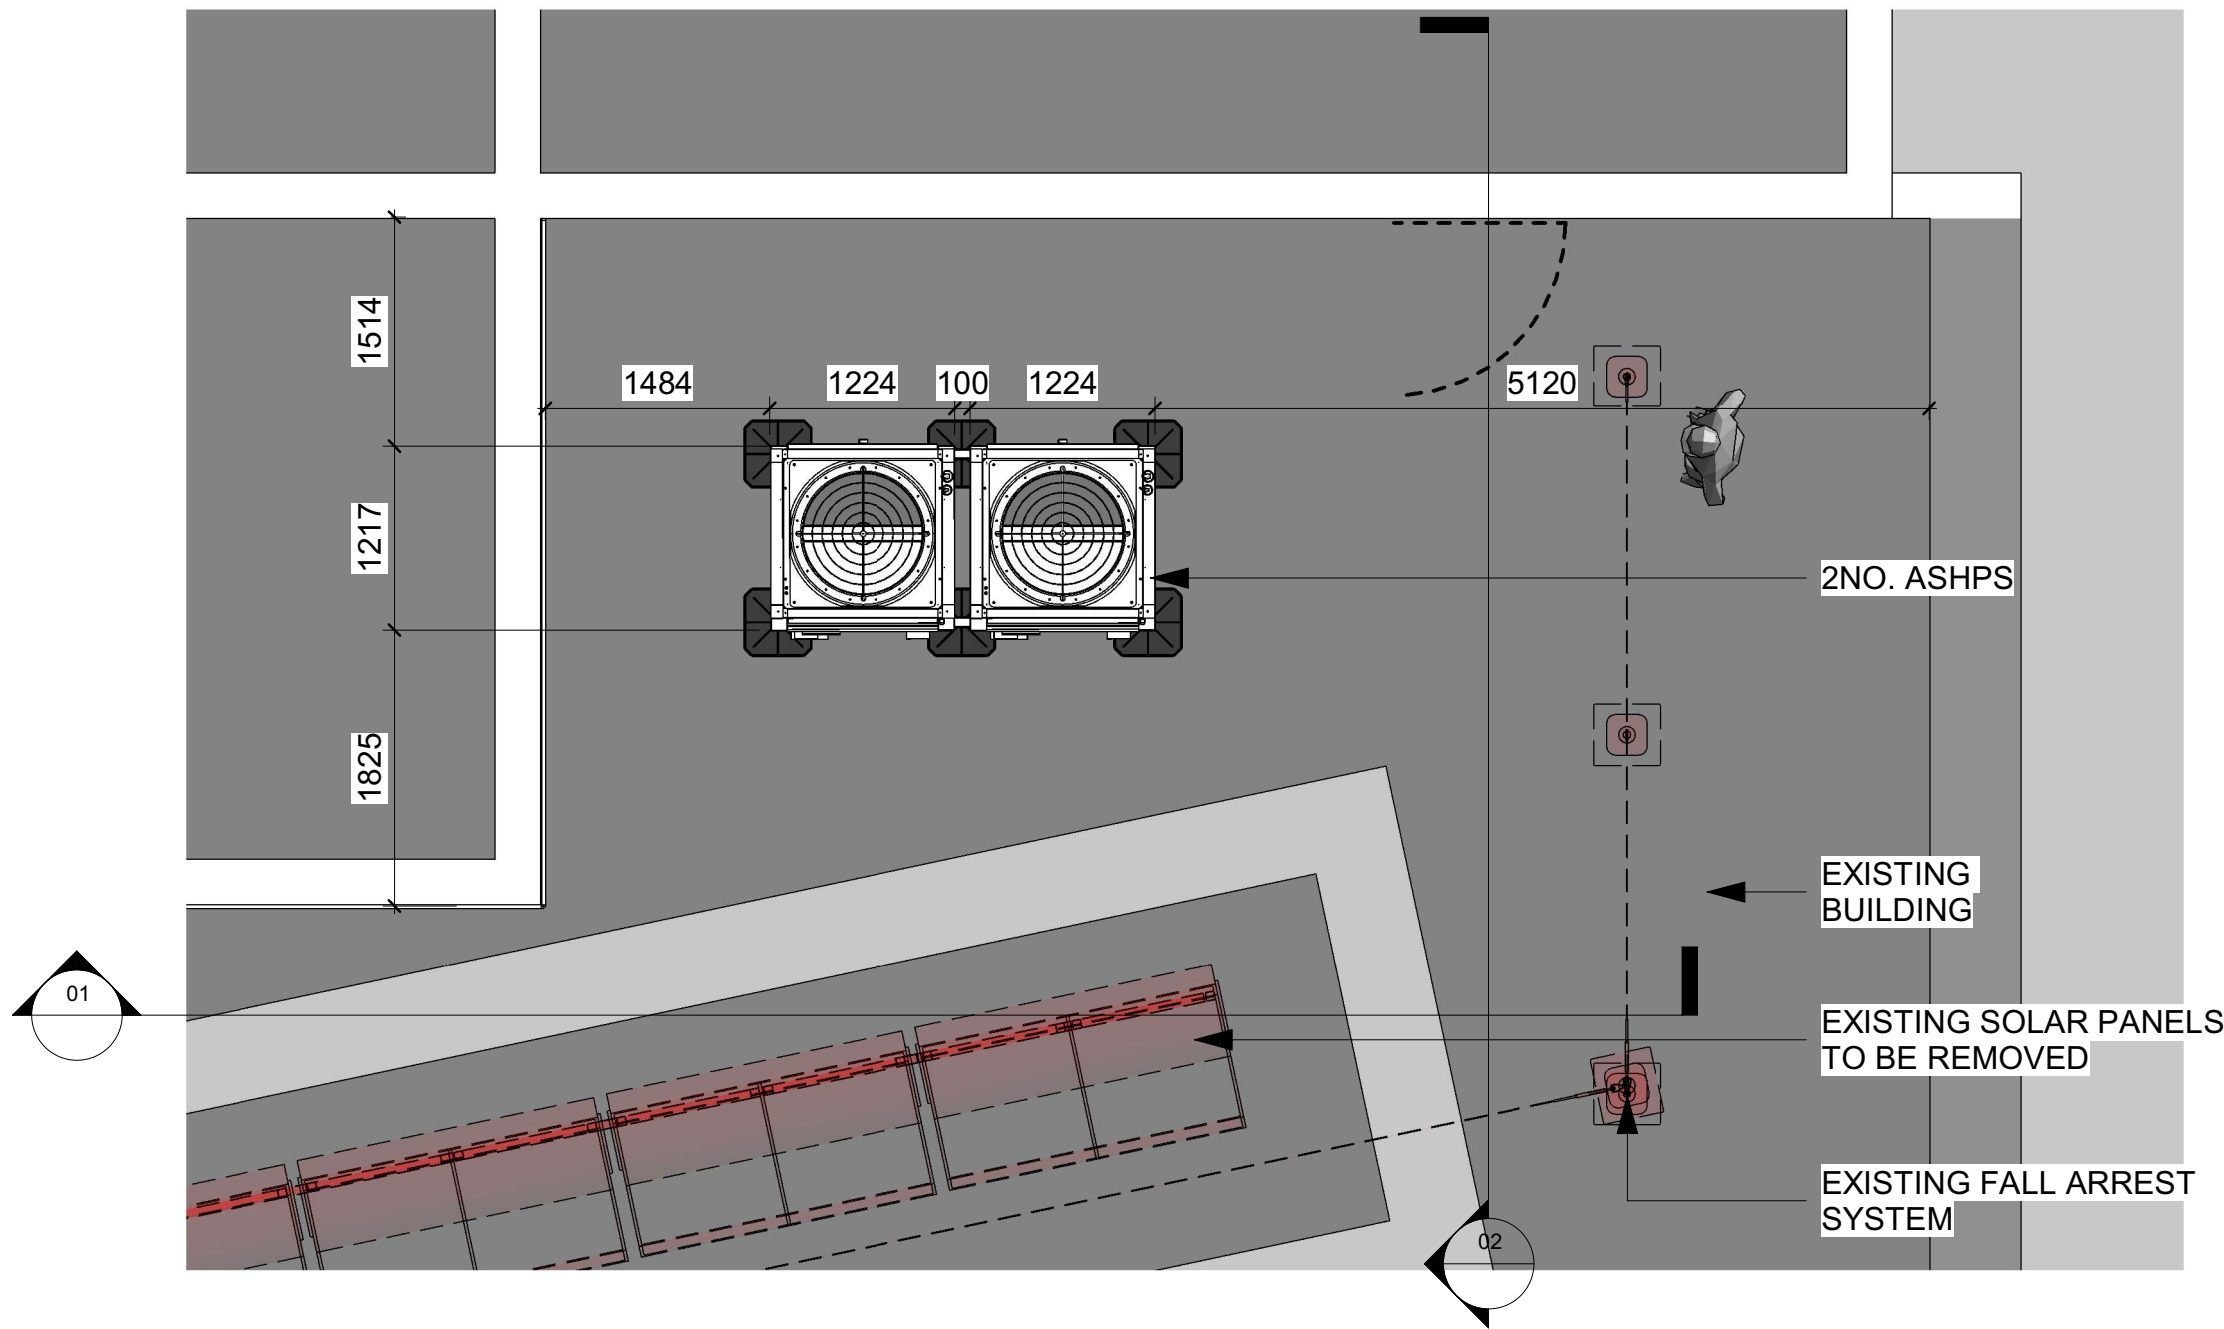


Rua Red Art Centre- Site Plan (Detailed) Copy 1
1 : 50

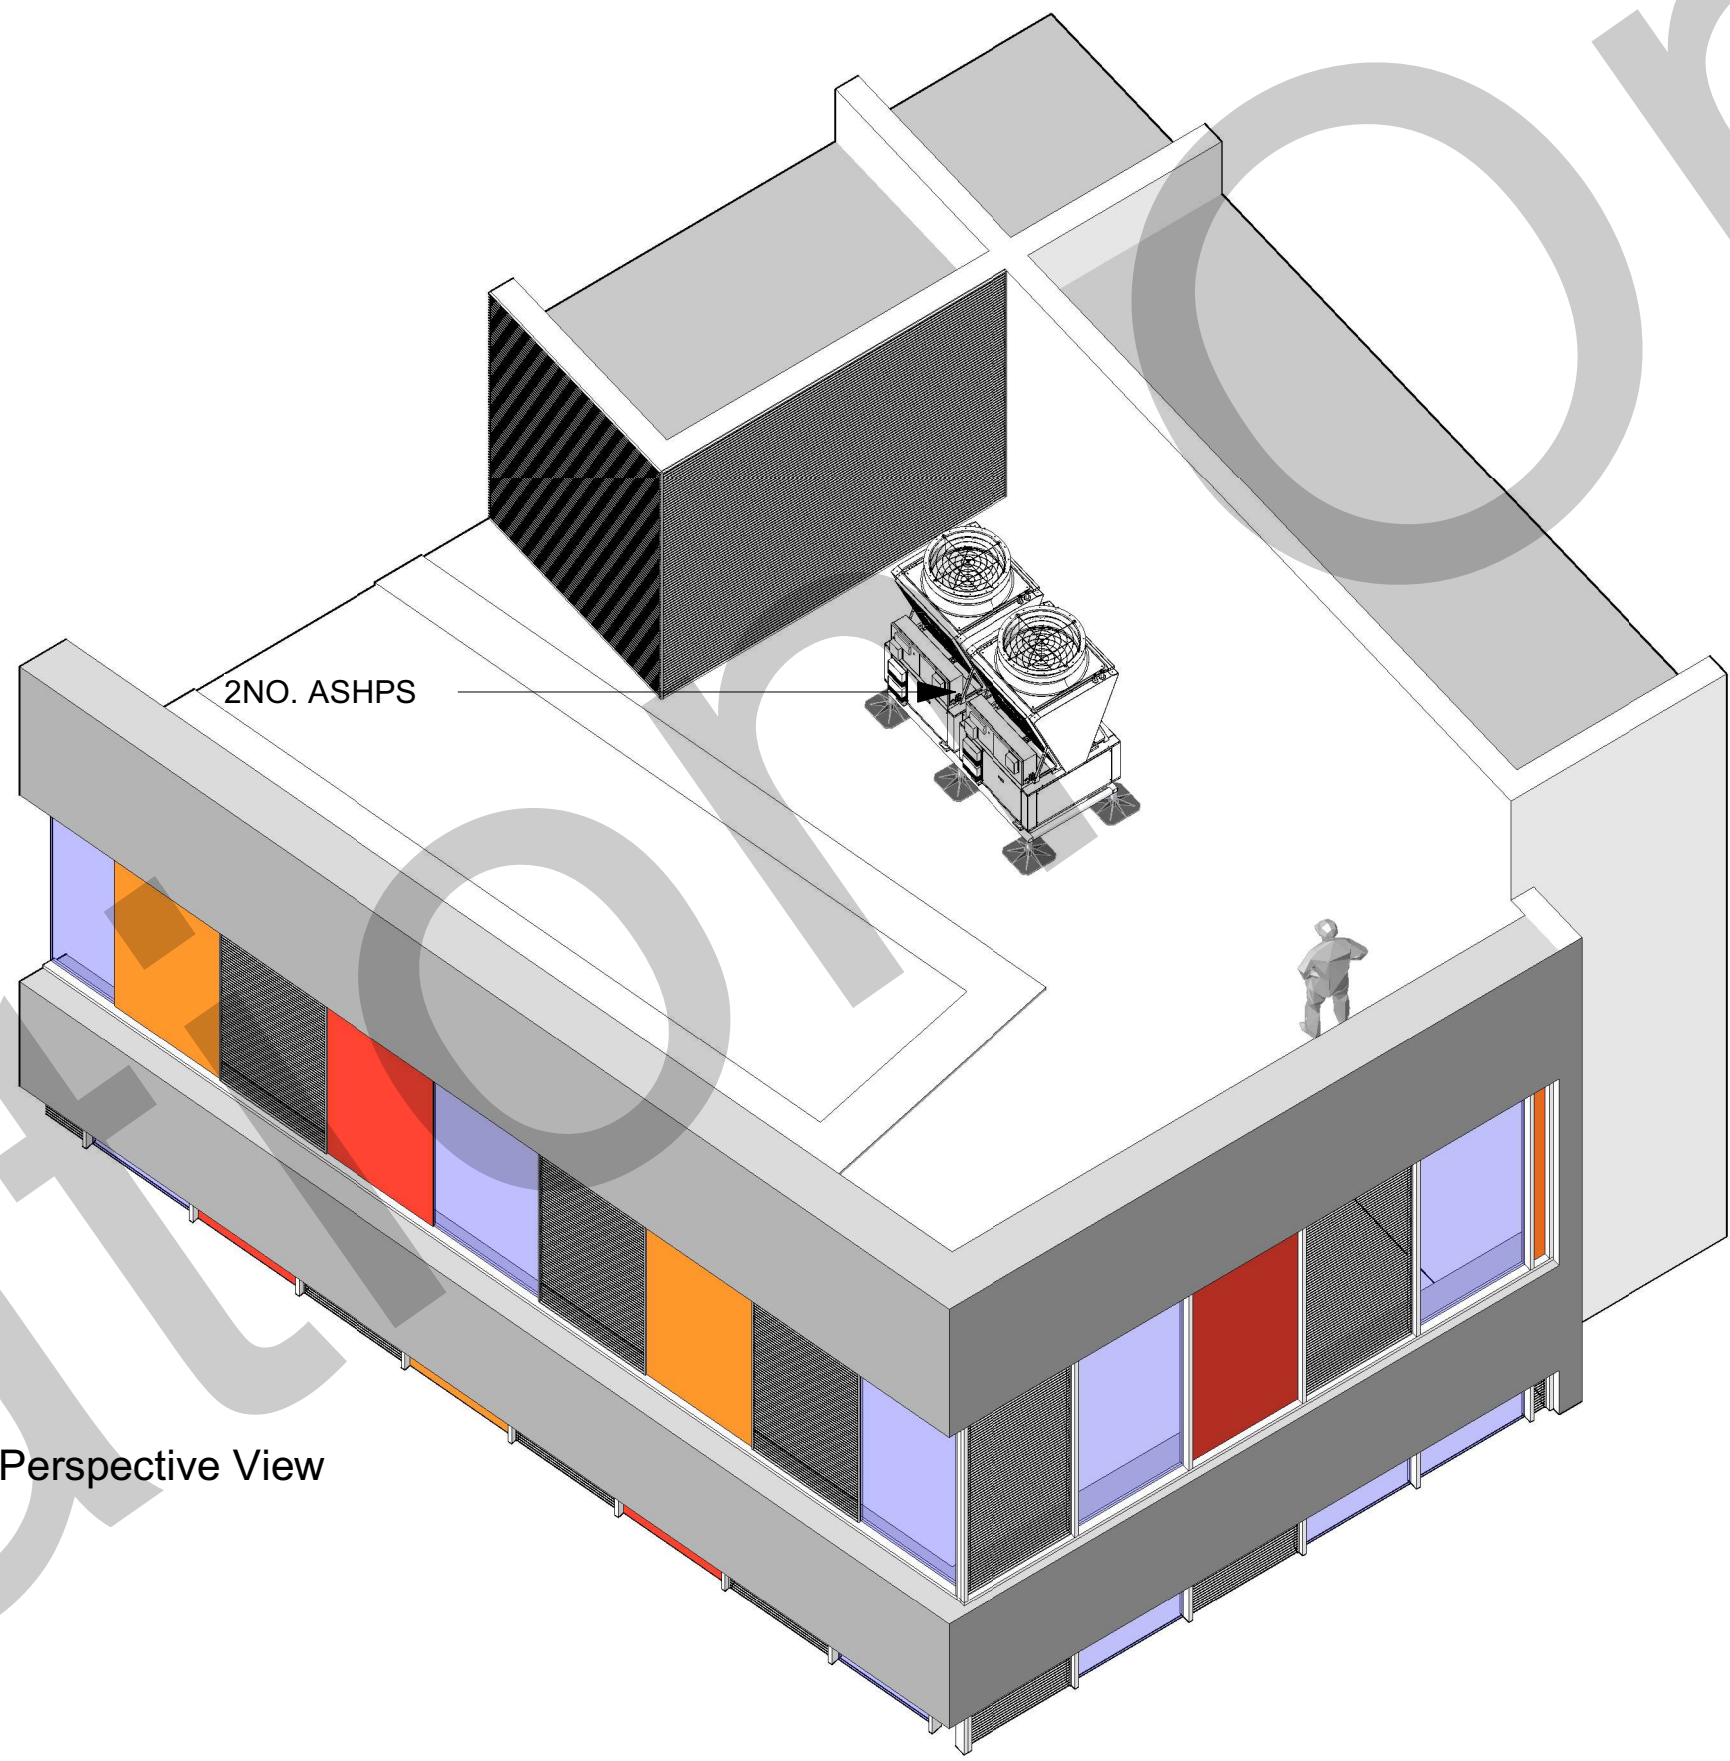

Rua Red Art Centre - Perspective View

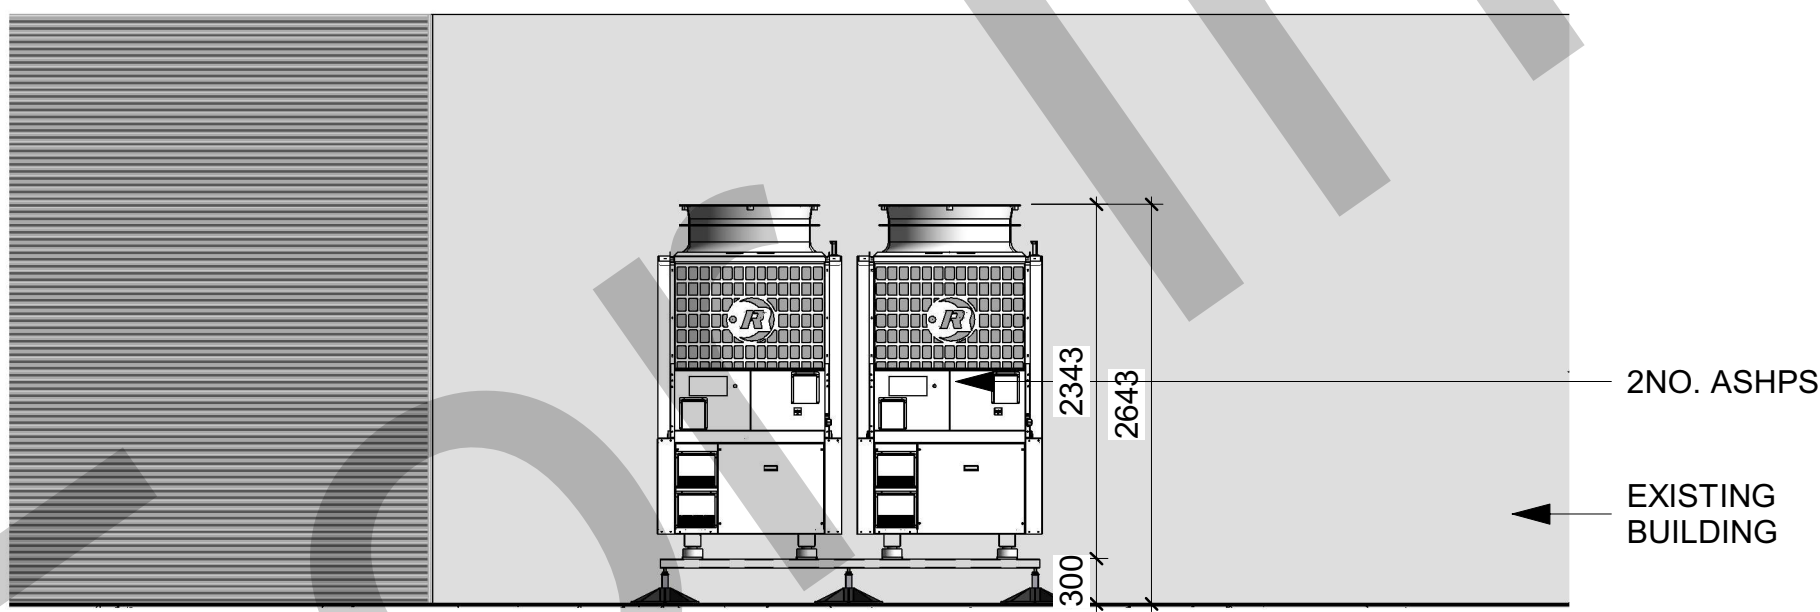

Rua Red Art Centre - Section 01
1 : 50

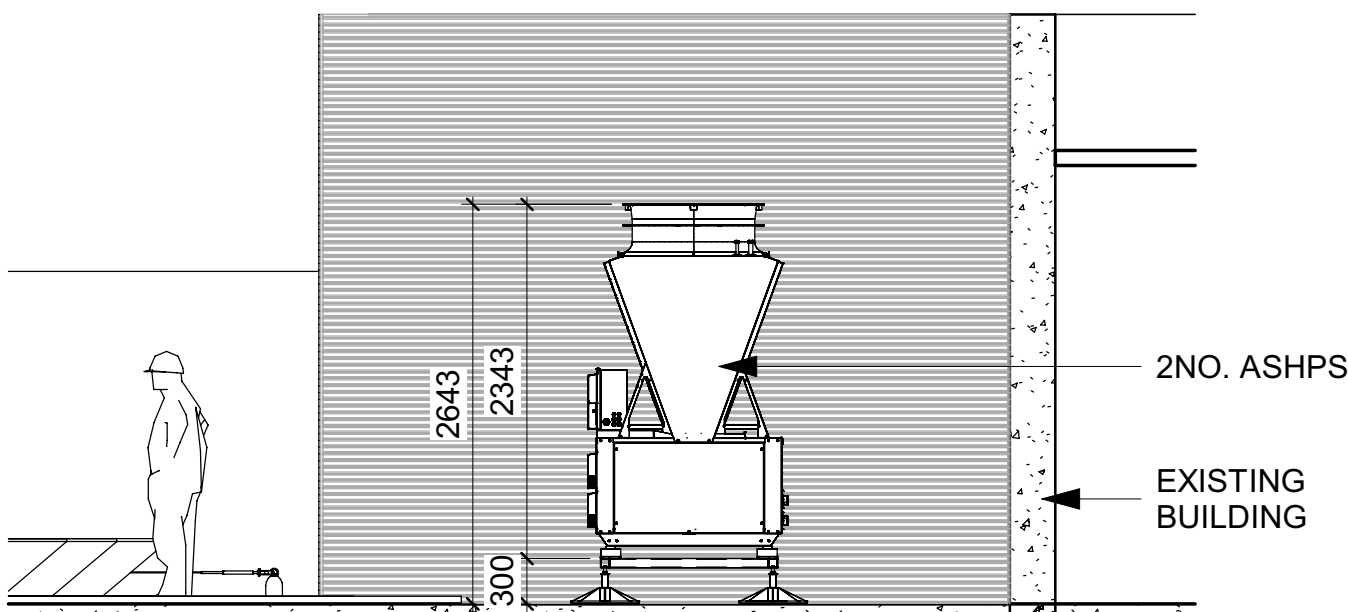

Rua Red Art Centre - Section 02
1 : 50

P01	Rev	05/05/26	FIRST ISSUE	JR	CF
	Rev	Date	Revision Notes	Rev	Chw

Client

Comhairle Contae
Alpha Clann Theas
South Dublin County Council



alternative**HEAT**
Commercial Energy Solutions

T: +44 (0) 28 4377 0700
E: info@alternativeheat.co.uk
U: Unit 15A, Scarra road Industrial Estate, Banbridge, BT32 3DD

Project

SOUTH DUBLIN COUNTY COUNCIL

Drawing Title

Rua Red - ASHP General Arrangement Plan

Project Status	Project Revision		
PLANNING	P01		
Scale@A1	Original Date	Drawn	Checked
1:50	05/05/26	JR	CF

Drawing Number

SDC2401-ALT-RAC-XX-PL-U-00002