


**LEGEND:**

EXISTING FOUL SEWER	---
EXISTING SURFACE WATER SEWER	---
PROPOSED FOUL SEWER	---
PROPOSED SURFACE WATER SEWER	---
PROPOSED ATTENUATION TANK	[Symbol]
PROPOSED GULLY	[Symbol]
PROPOSED PERMEABLE SURFACE TO LANDSCAPE ARCHITECTS DETAIL	[Symbol]
PROPOSED TREE PIT	[Symbol]
PROPOSED TREE PIT OVERFLOW	[Symbol]
FOUL CURRENTLY UNDER CONSTRUCTION	---
SURFACE WATER CURRENTLY UNDER CONSTRUCTION	---
PROPOSED ROAD UNDER CONSTRUCTION BY OTHERS. REF: 3D178/0007	[Symbol]

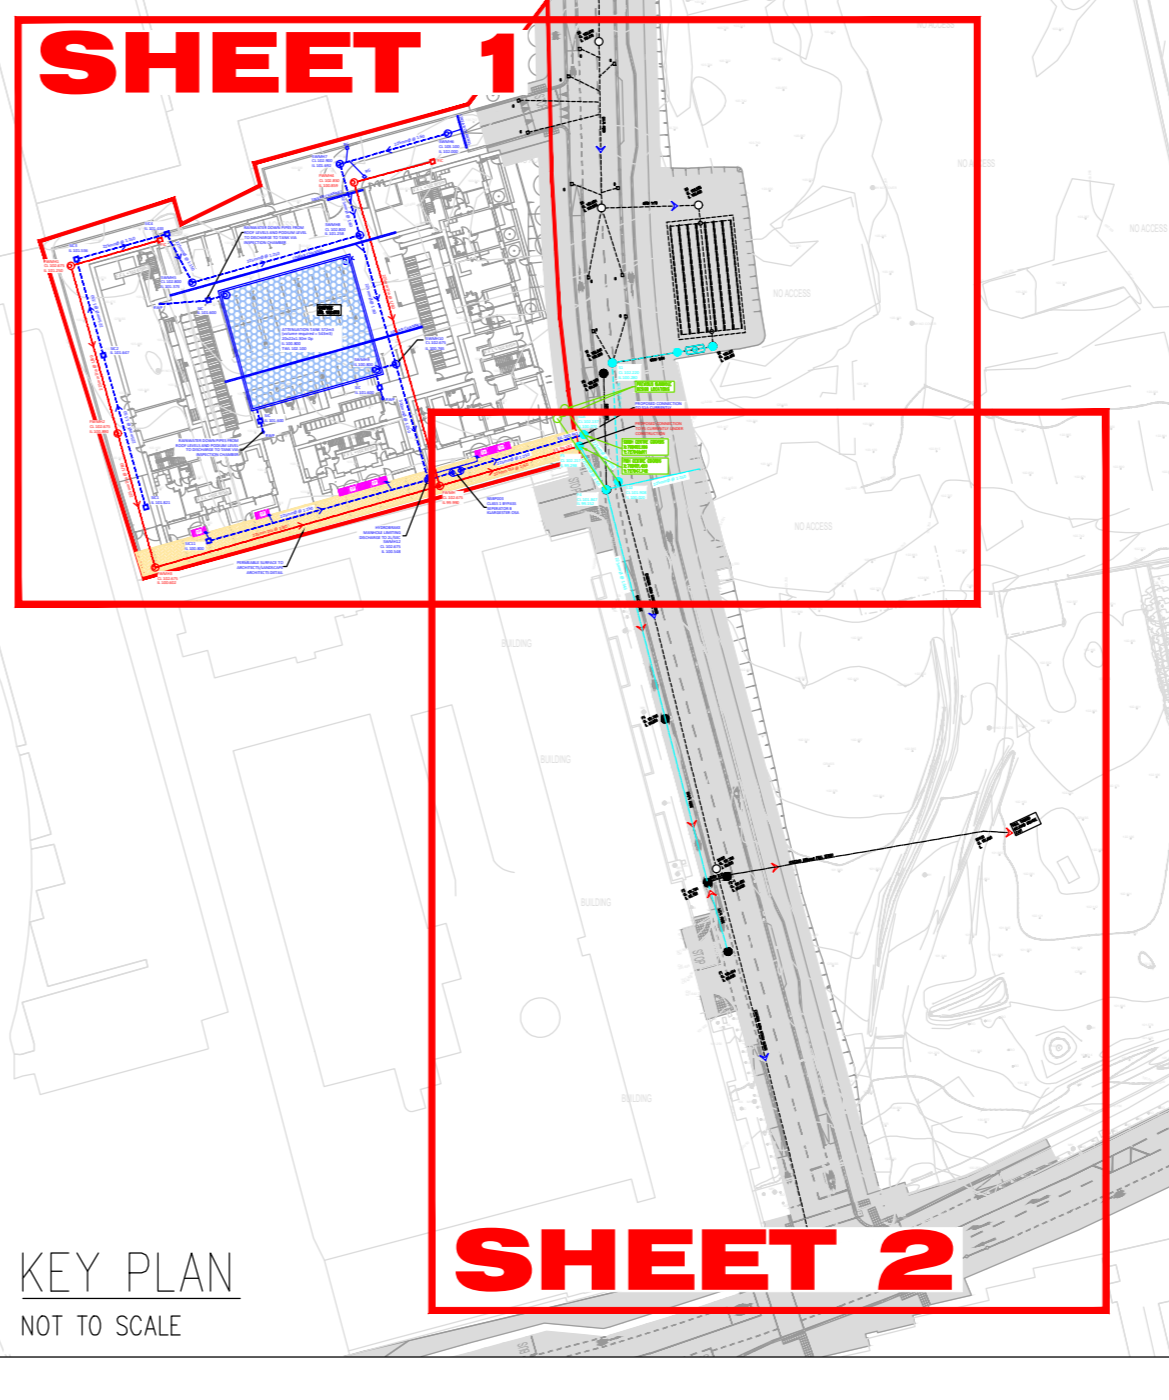

PROPOSED DRAINAGE LAYOUT.  
SCALE= 1:200

**PLANNING DRAWING.**  
NOT FOR CONSTRUCTION.  
ALL LEVELS GIVEN ARE  
RELATIVE TO ORDNANCE DATUM.  
THIS DRAWING HAS BEEN ISSUED FOR INFORMATION  
PURPOSES ONLY AND MUST NOT BE USED  
FOR CONSTRUCTION UNDER ANY CIRCUMSTANCES

**NOTES**

- For setting out refer to Architect's drawings.
- This drawing to be read in conjunction with all other Architectural and Engineering drawings and all other relevant drawings and Specifications.
- DO NOT SCALE THIS DRAWING. Use figured dimensions only.
- No part of this document may be reproduced or transmitted in any form or stored in any retrieval system of any nature without the written permission as copyright holder except as agreed for use on the project for which the document was originally issued.
- Ordnance Survey Ireland Licence Number EN 0074020

Rev. No.	Date	REVISION NOTE	Dm. By	Chkd. By

Architect	Coady Architects			
Project	Belgard Square North Tallaght			
Title	Proposed Drainage Layout Sheet 2 Of 2			
Dwg. No.	TAL-CSC-ZZ-XX-DR-C-0004			
Date	Dm by	Chkd by	Appr by	Scale
28.04.2020	AB	GS	NB	1:200 @A1

**CS Consulting Group**  
DUBLIN | LONDON | LIMERICK

Head Office  
19-22 Dame Street, Dublin 2.  
T: +353 (0)1 5480863 F: +353 (0)1 9011355  
e: info@csconsulting.ie  
w: www.csconsulting.ie

Quality I.S. EN ISO 9001:2008  
Environment I.S. EN ISO 14001:2004  
NSAI Certified Health & Safety OHSAS 18001:2007