


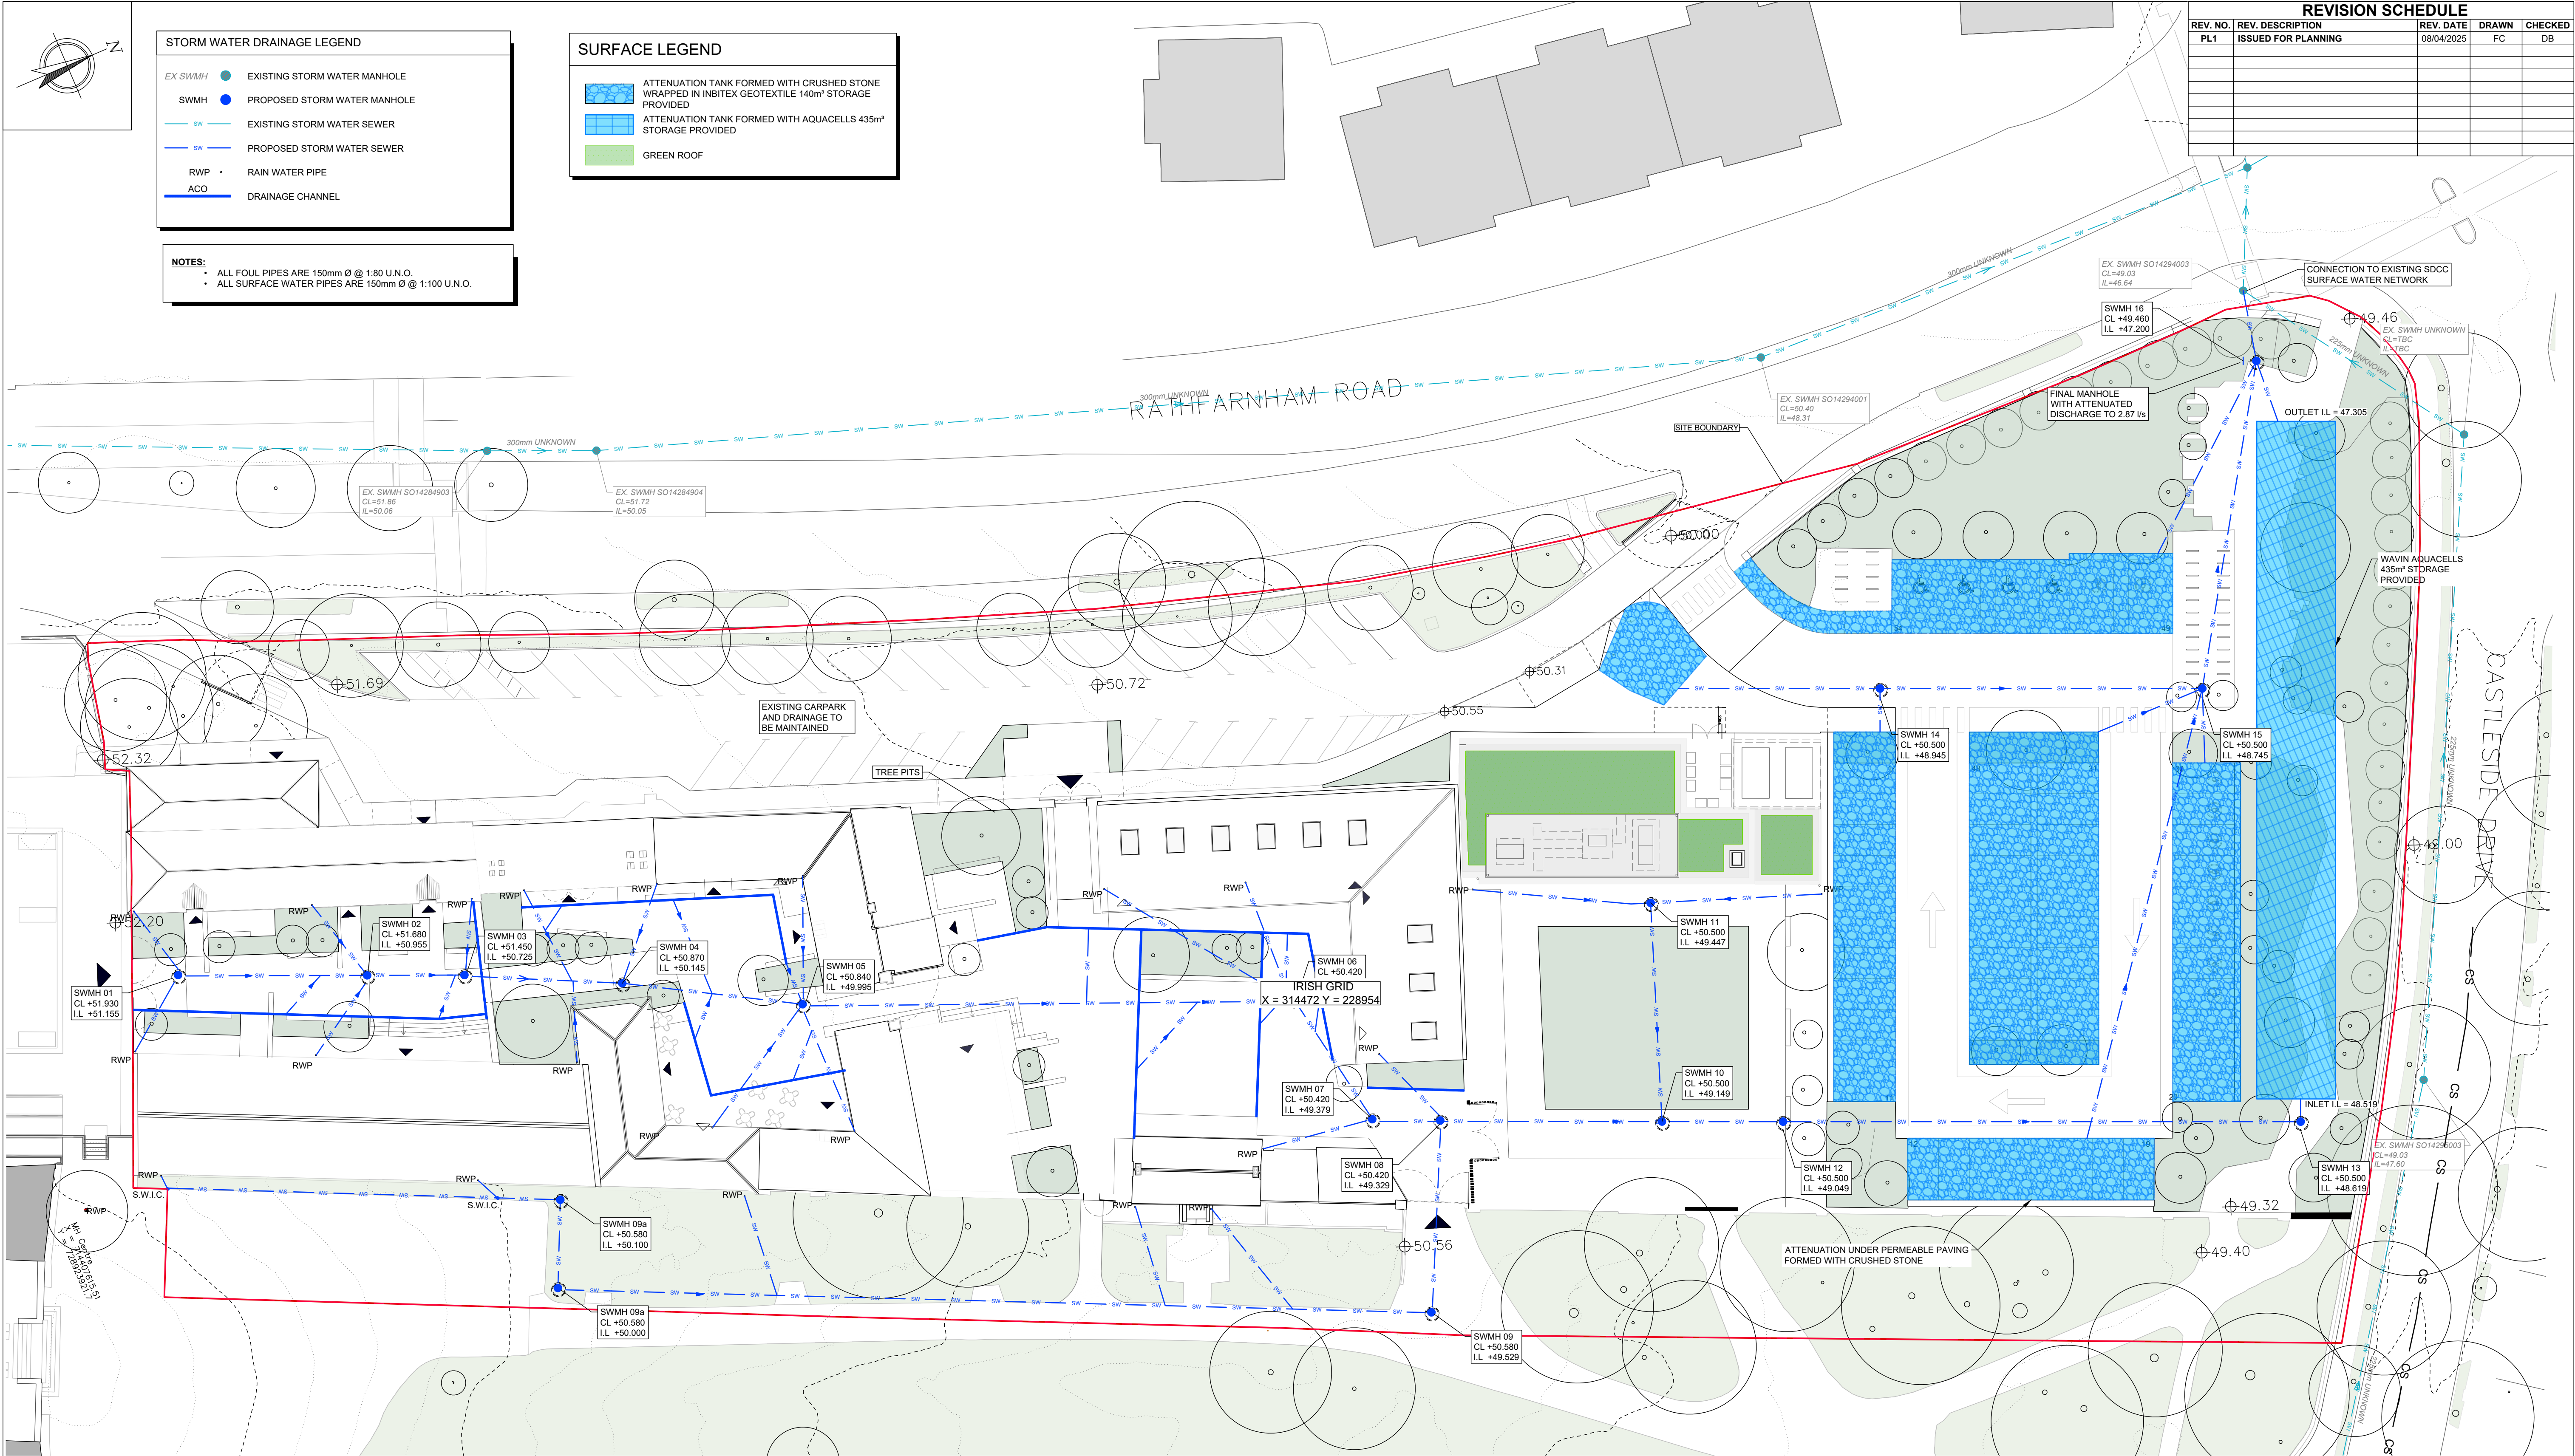

REVISION SCHEDULE				
REV. NO.	REV. DESCRIPTION	REV. DATE	DRAWN	CHECKED
PL1	ISSUED FOR PLANNING	08/04/2025	FC	DB

- NOTES:**
- ALL FOUL PIPES ARE 150mm Ø @ 1:80 U.N.O.
 - ALL SURFACE WATER PIPES ARE 150mm Ø @ 1:100 U.N.O.

Drawing Stage: PLANNING			Project Details:		Notes										Drawn by:		Checked by:		Approved by:		Date:		CORA CONSULTING ENGINEERS Behan House, 10 Lower Mount Street, Dublin 2, D02 HT71 Tel: +353 1 661 1100 e-mail: info@cora.ie Web: www.cora.ie																	
			Site Address:	RATHFARNHAM CASTLE, D14 K3T6.											FC		DB		LE		08/04/2025																			
			Client:	SOUTH DUBLIN COUNTY COUNCIL											Project Name:						Scale:												Project Number:							
			Architect:	HHC ARCHITECTS											RATHFARNHAM CASTLE COURTYARD						1:250 @ A1												2332							
			M&E Designer:	HORMAN O'BRIEN											Drawing Title:						Project:												Originator:	Zone:	Level:	Type:	Discipline:	Drawing No:	Stage:	Revision:
			Contractor:																		SURFACE WATER DRAINAGE LAYOUT												RCC		CORA	ZZ	ZZZ	DR	C	0001