



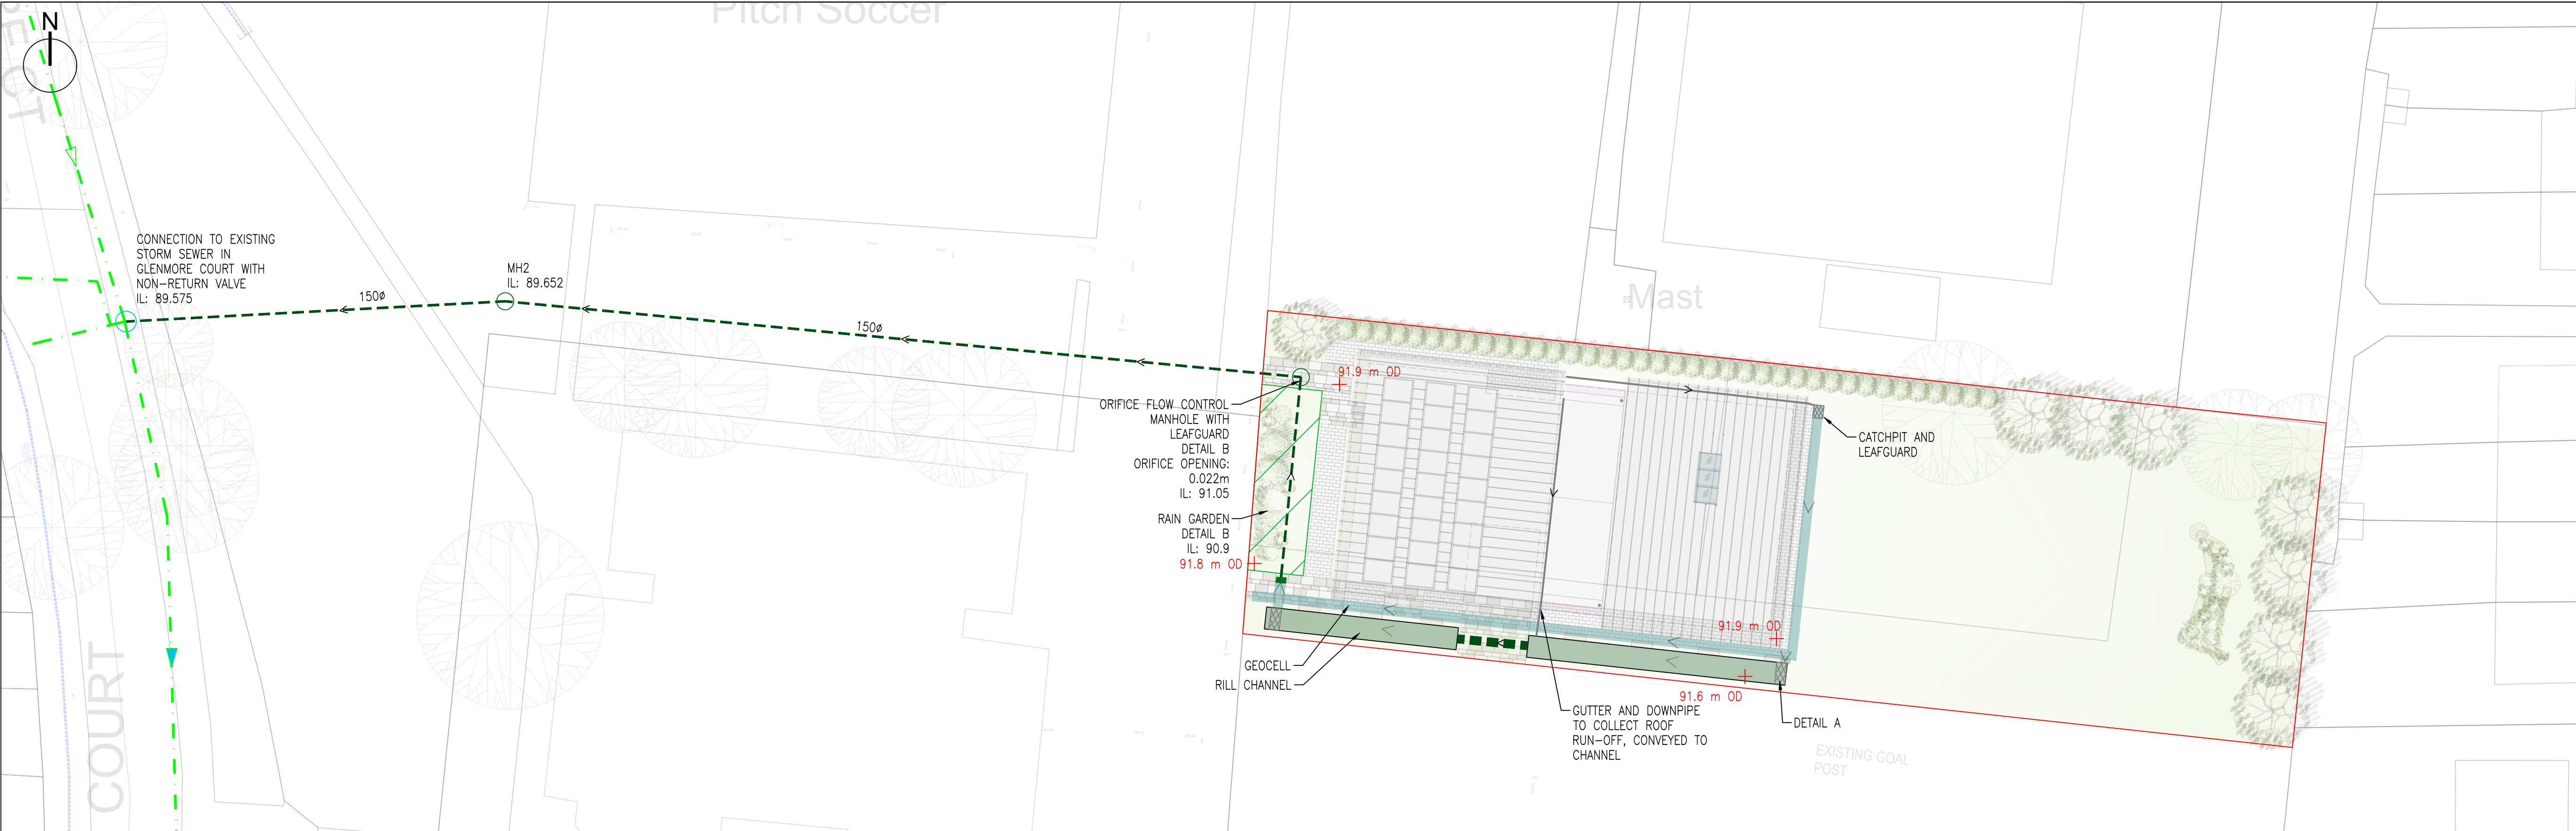


- GENERAL NOTES**
- DO NOT SCALE FROM THIS DRAWING.
 - ALL DIMENSIONS TO BE CHECKED ON SITE.
 - COPYRIGHT PROTECTED.
 - THIS LEGEND APPLIES TO ALL DRAWINGS WITHIN THIS SERIES. NOT ALL SYMBOLS, LINE TYPES, HATCHES, OR ANNOTATIONS SHOWN MAY APPEAR ON EVERY DRAWING.
- LEGEND**
- SITE BOUNDARY
 - RAIN GARDEN
 - GEOCELL
 - RILL PLANTED CHANNEL
 - SURFACE WATER SEWER
 - GUTTER AND DOWNPIPE
 - EXISTING SURFACE WATER SEWER
 - MAN HOLE / INSPECTION CHAMBER
 - PROPOSED FFL/FGI
 - STAINLESS STEEL COWL

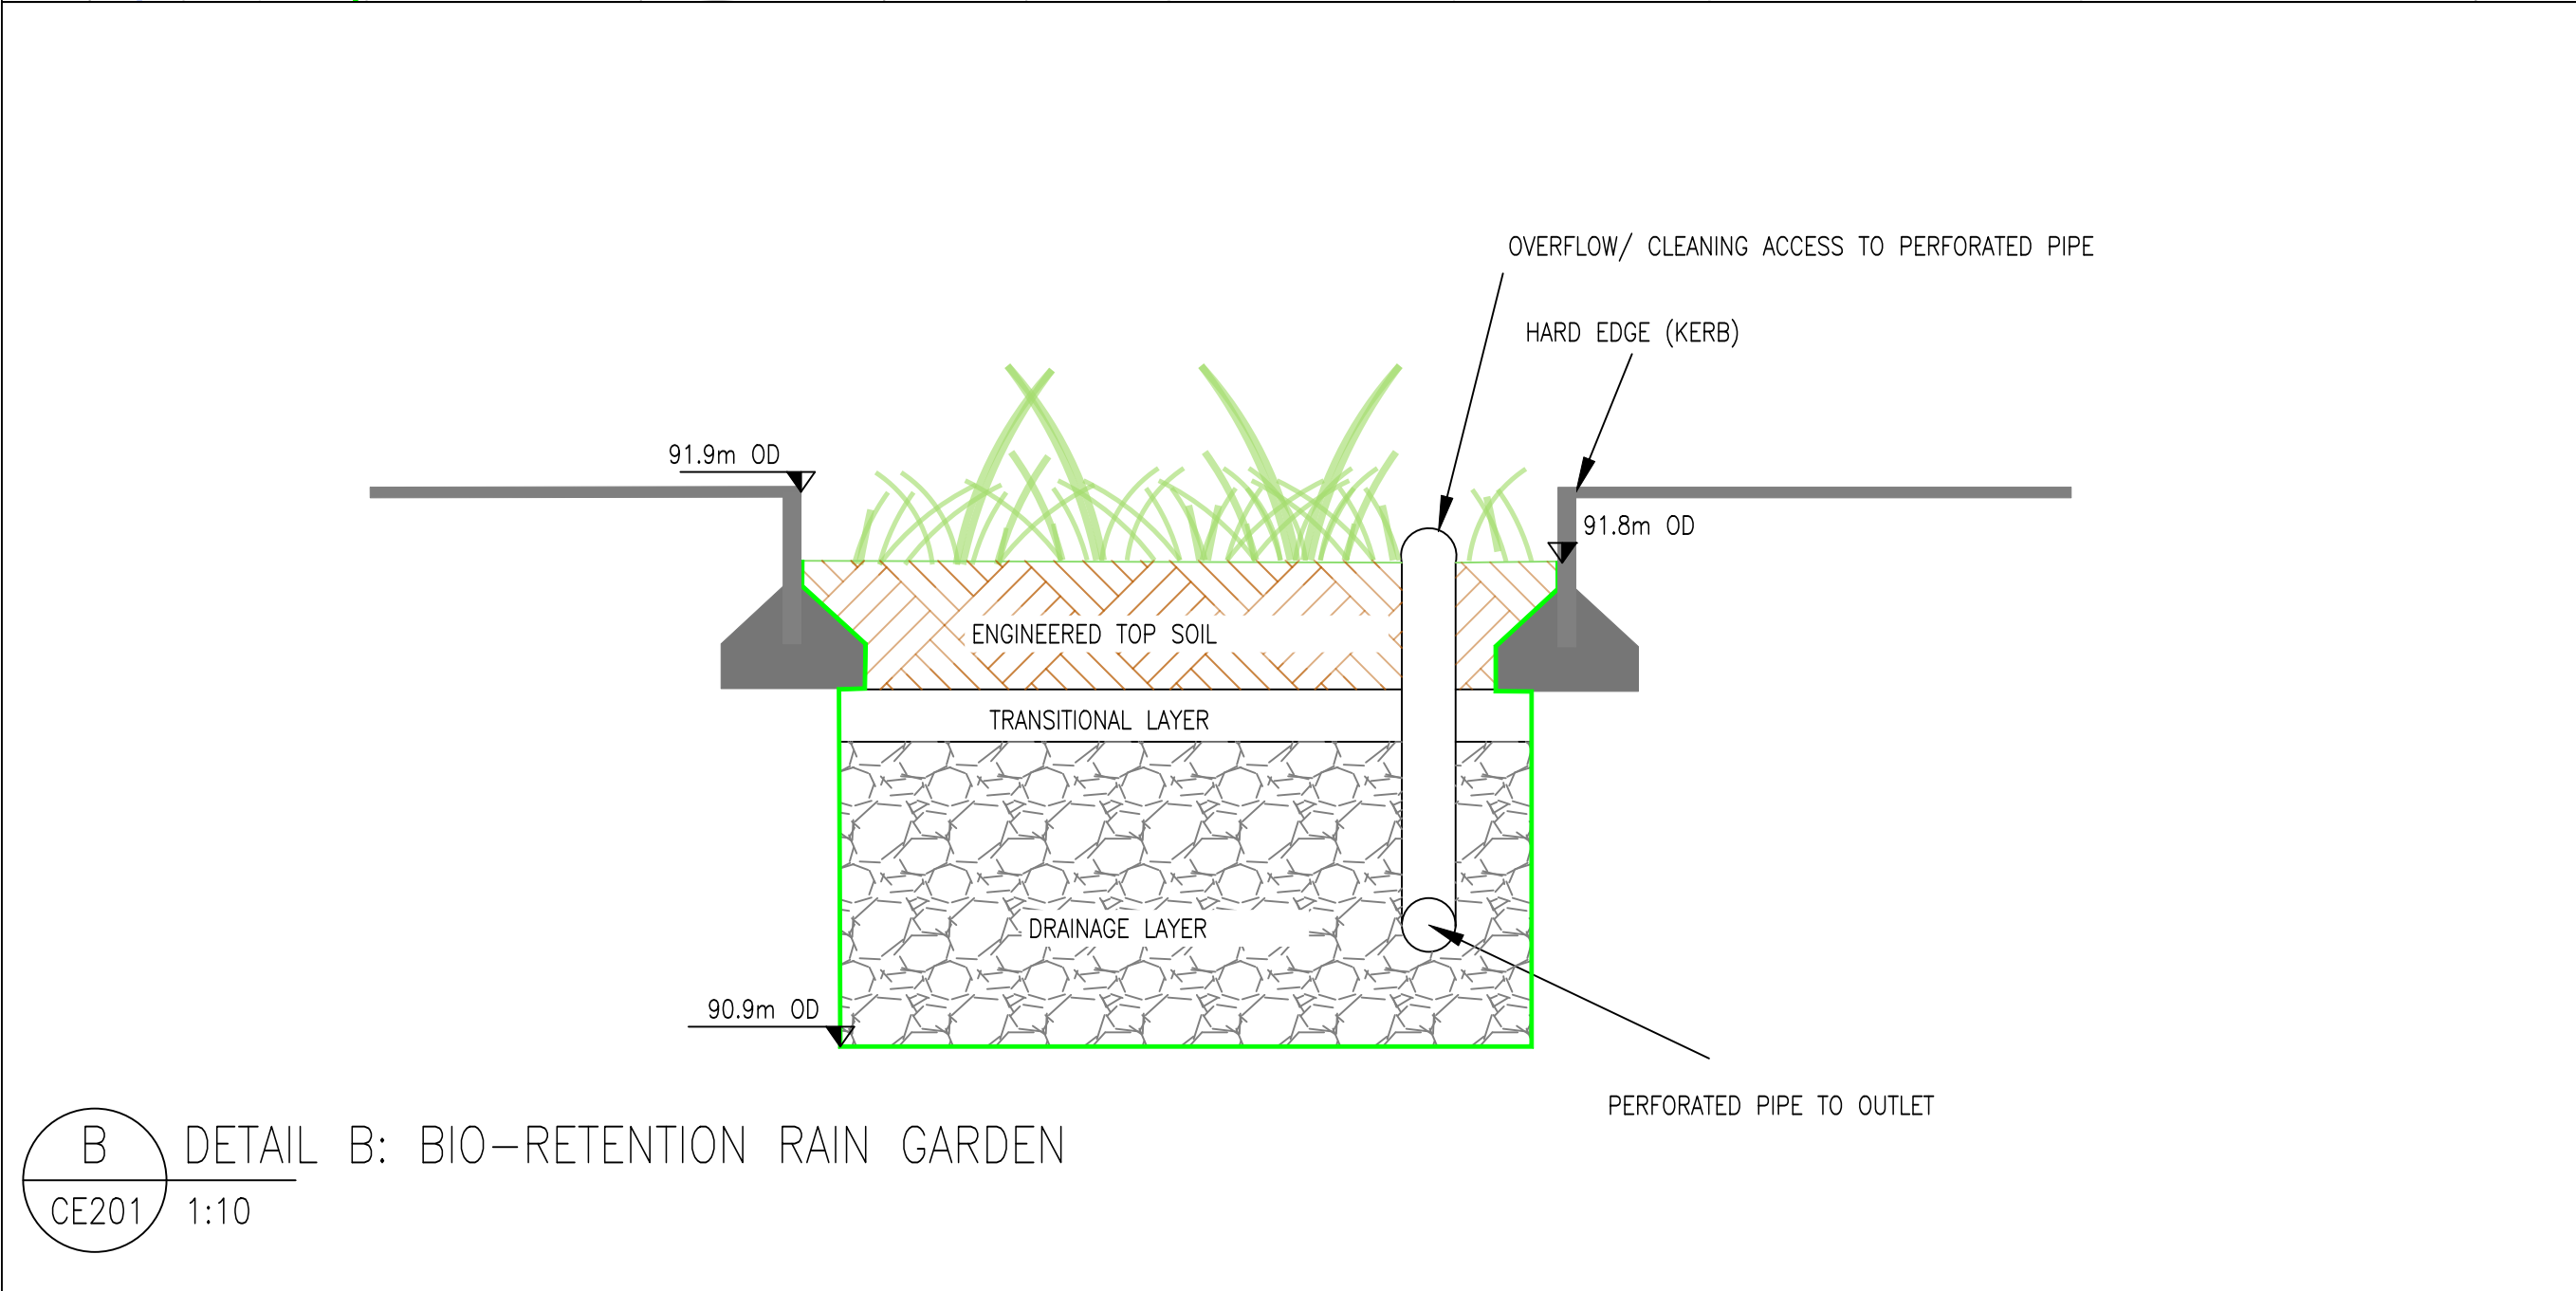


B DETAIL B: BIO-RETENTION RAIN GARDEN
CE201 1:10

1 PROPOSED DEVELOPMENT
CE201 1:250

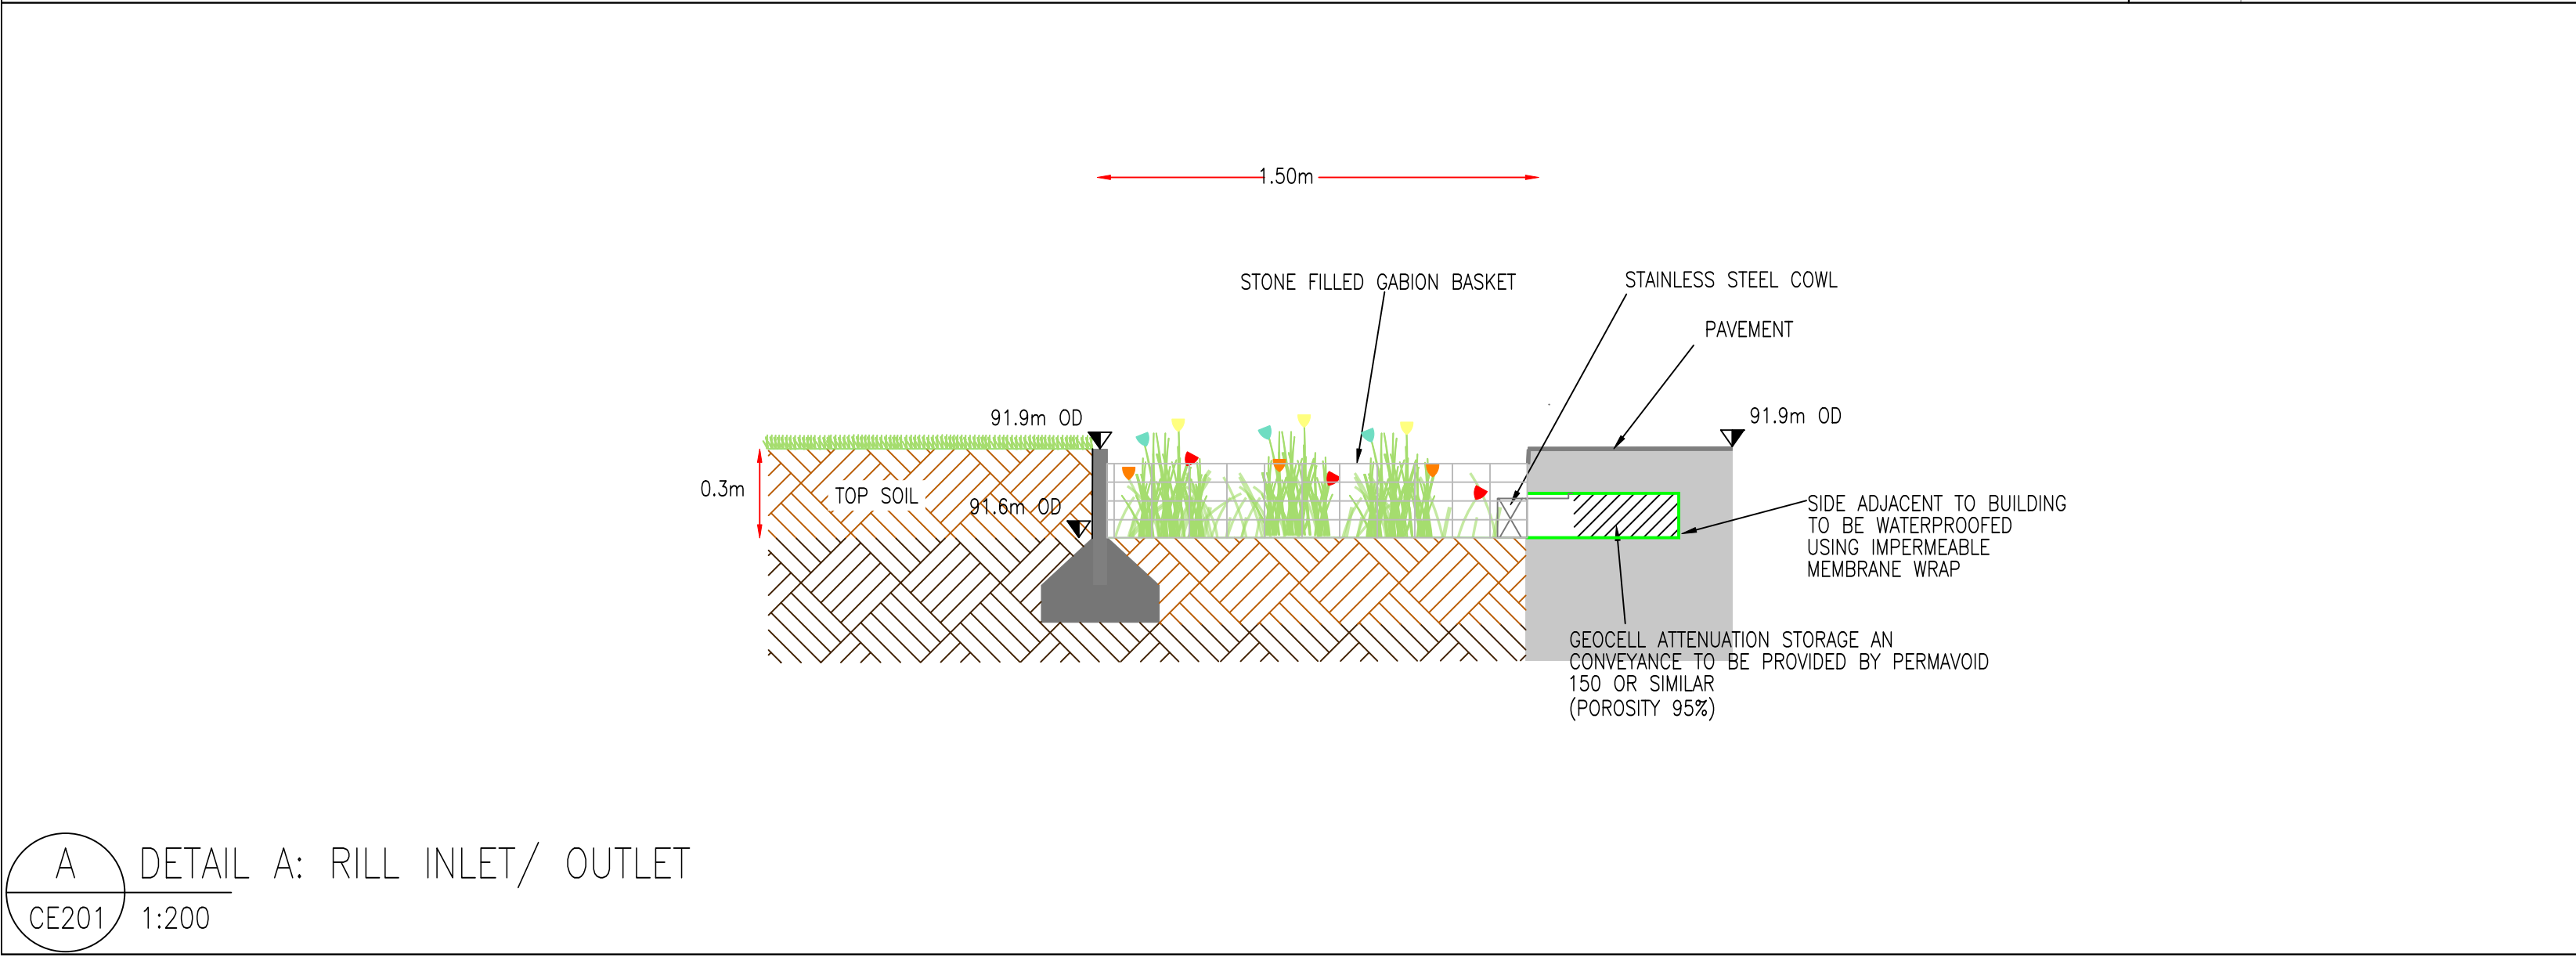

A DETAIL A: RILL INLET/ OUTLET
CE201 1:200

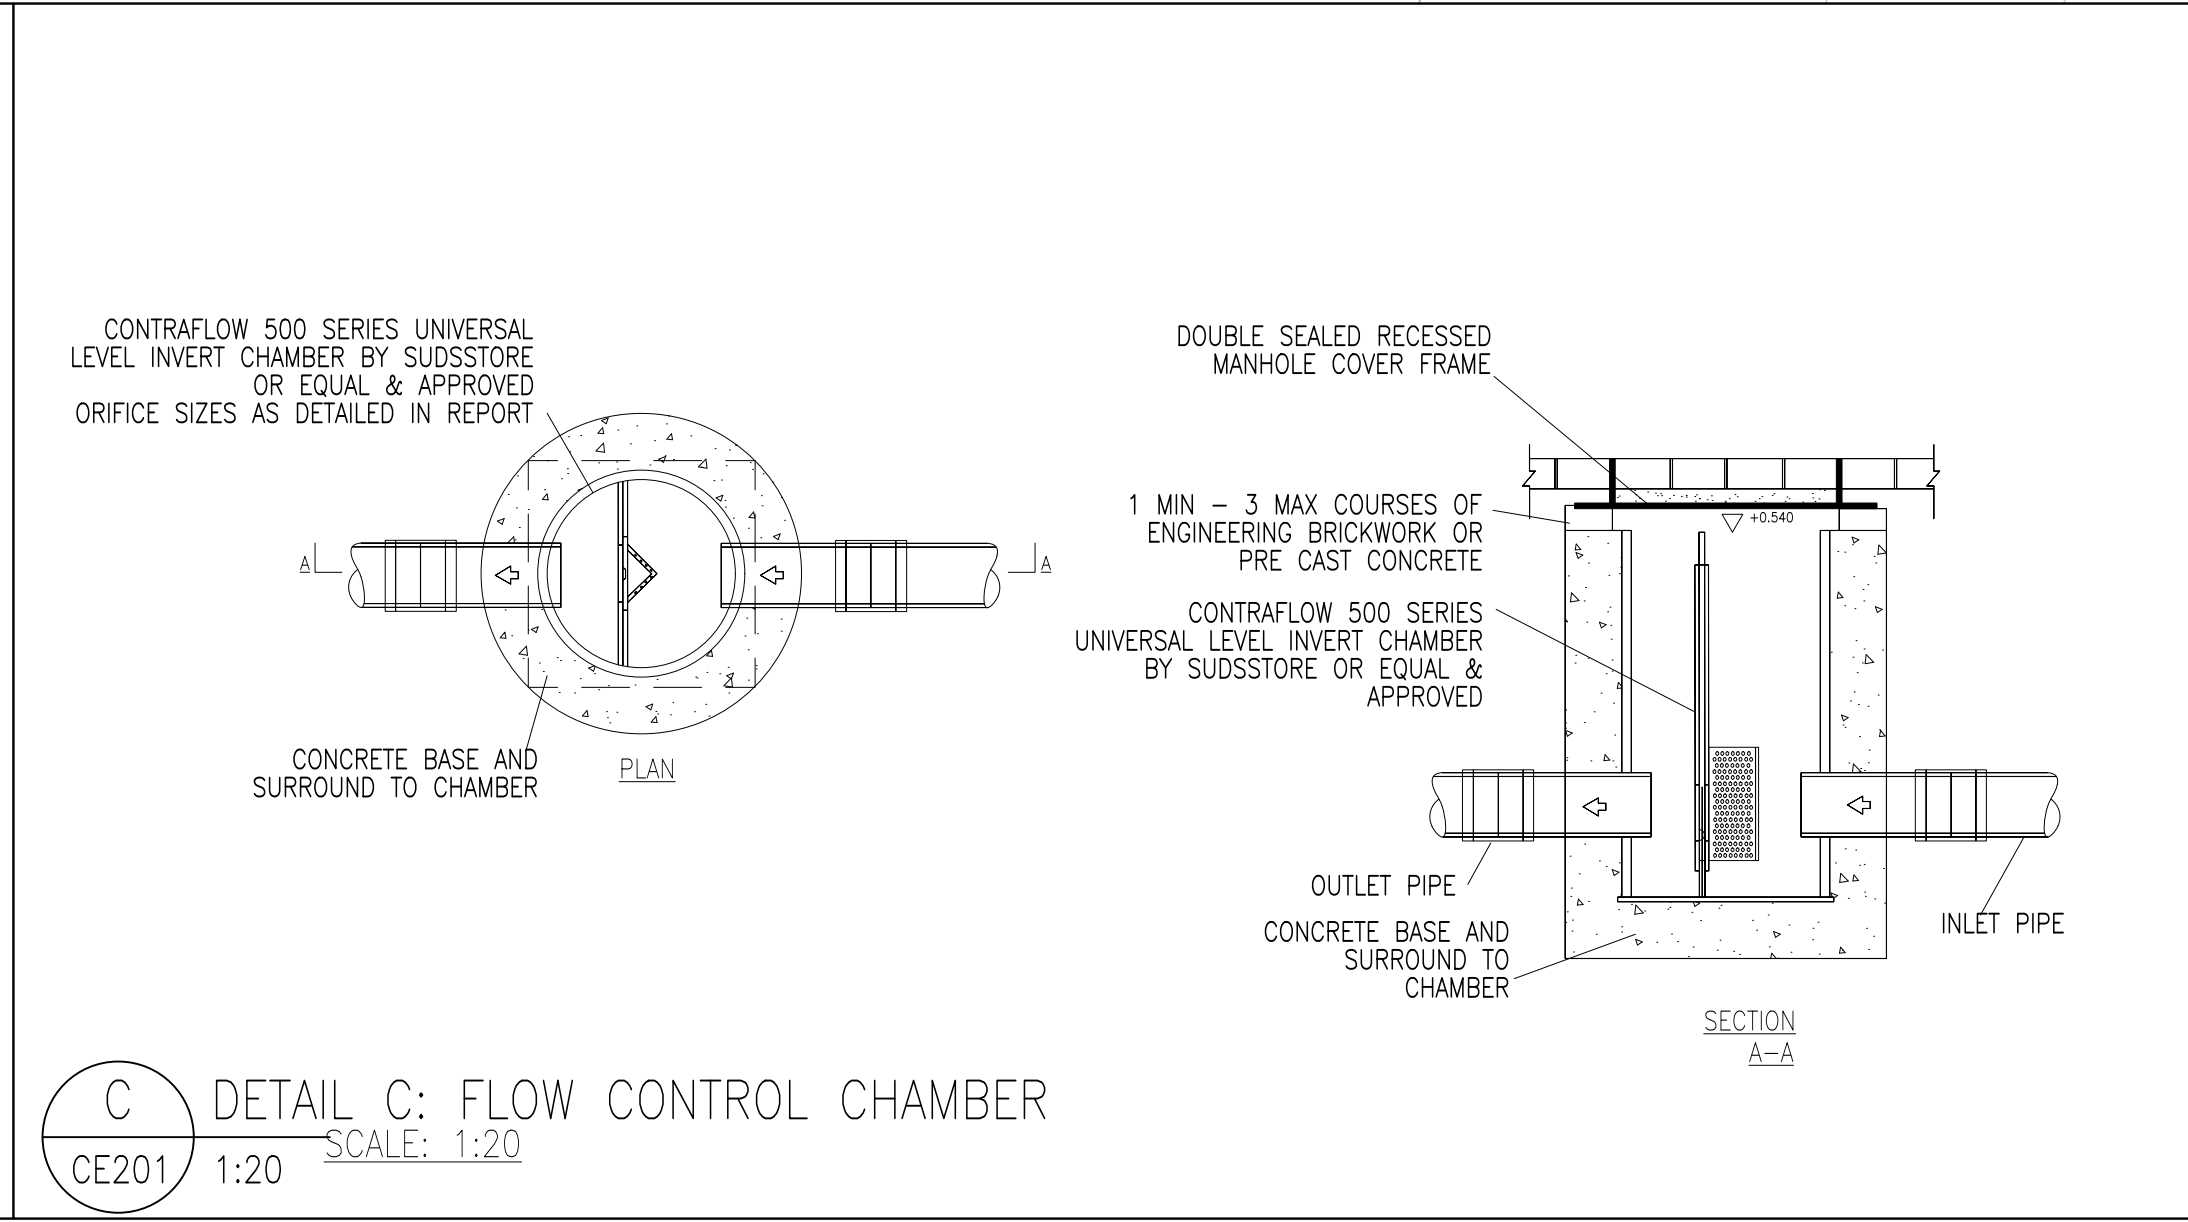

C DETAIL C: FLOW CONTROL CHAMBER
CE201 1:20 SCALE: 1:20

NOT FOR CONSTRUCTION

DO	IB	AM	25/06/26	ORIGINAL - FOR PART 8 SUBMISSION
ISSUE	DRN	APP	DATE	NOTES / DESCRIPTION

FOR PART 8 SUBMISSION

McCloy Consulting

T: 028 9084 8694
E: info@mccloyconsulting.com
W: www.mccloyconsulting.com

Mosley Mill, Lower Ground (West)
Carmoney Road North
Newtownslilly
Co. Antrim, BT36 5QA

WHITECHURCH SPORTS FACILITY

SOUTH DUBLIN CITY COUNCIL

CONCEPT DRAINAGE LAYOUT GENERAL ARRANGEMENT

SCALE: AS SHOWN ORIGINAL SHEET SIZE: A1 PROJECT NO: M02138-07

DRAWING NO: CE 201-P0