


LEGEND:

EXISTING FOUL SEWER	---
EXISTING SURFACE WATER SEWER	- - - -
PROPOSED FOUL SEWER	---
PROPOSED SURFACE WATER SEWER	- - - -
PROPOSED ATTENUATION TANK	[Blue Box]
PROPOSED GULLY	[Blue Circle]
PROPOSED PERMEABLE SURFACE TO LANDSCAPE ARCHITECTS DETAIL	[Yellow Hatched Box]
PROPOSED TREE PIT	[Green Box]
PROPOSED TREE PIT OVERFLOW	[Green Box]
FOUL CURRENTLY UNDER CONSTRUCTION	---
SURFACE WATER CURRENTLY UNDER CONSTRUCTION	- - - -

PROPOSED ROAD UNDER CONSTRUCTION BY OTHERS. REF: SD178/0007

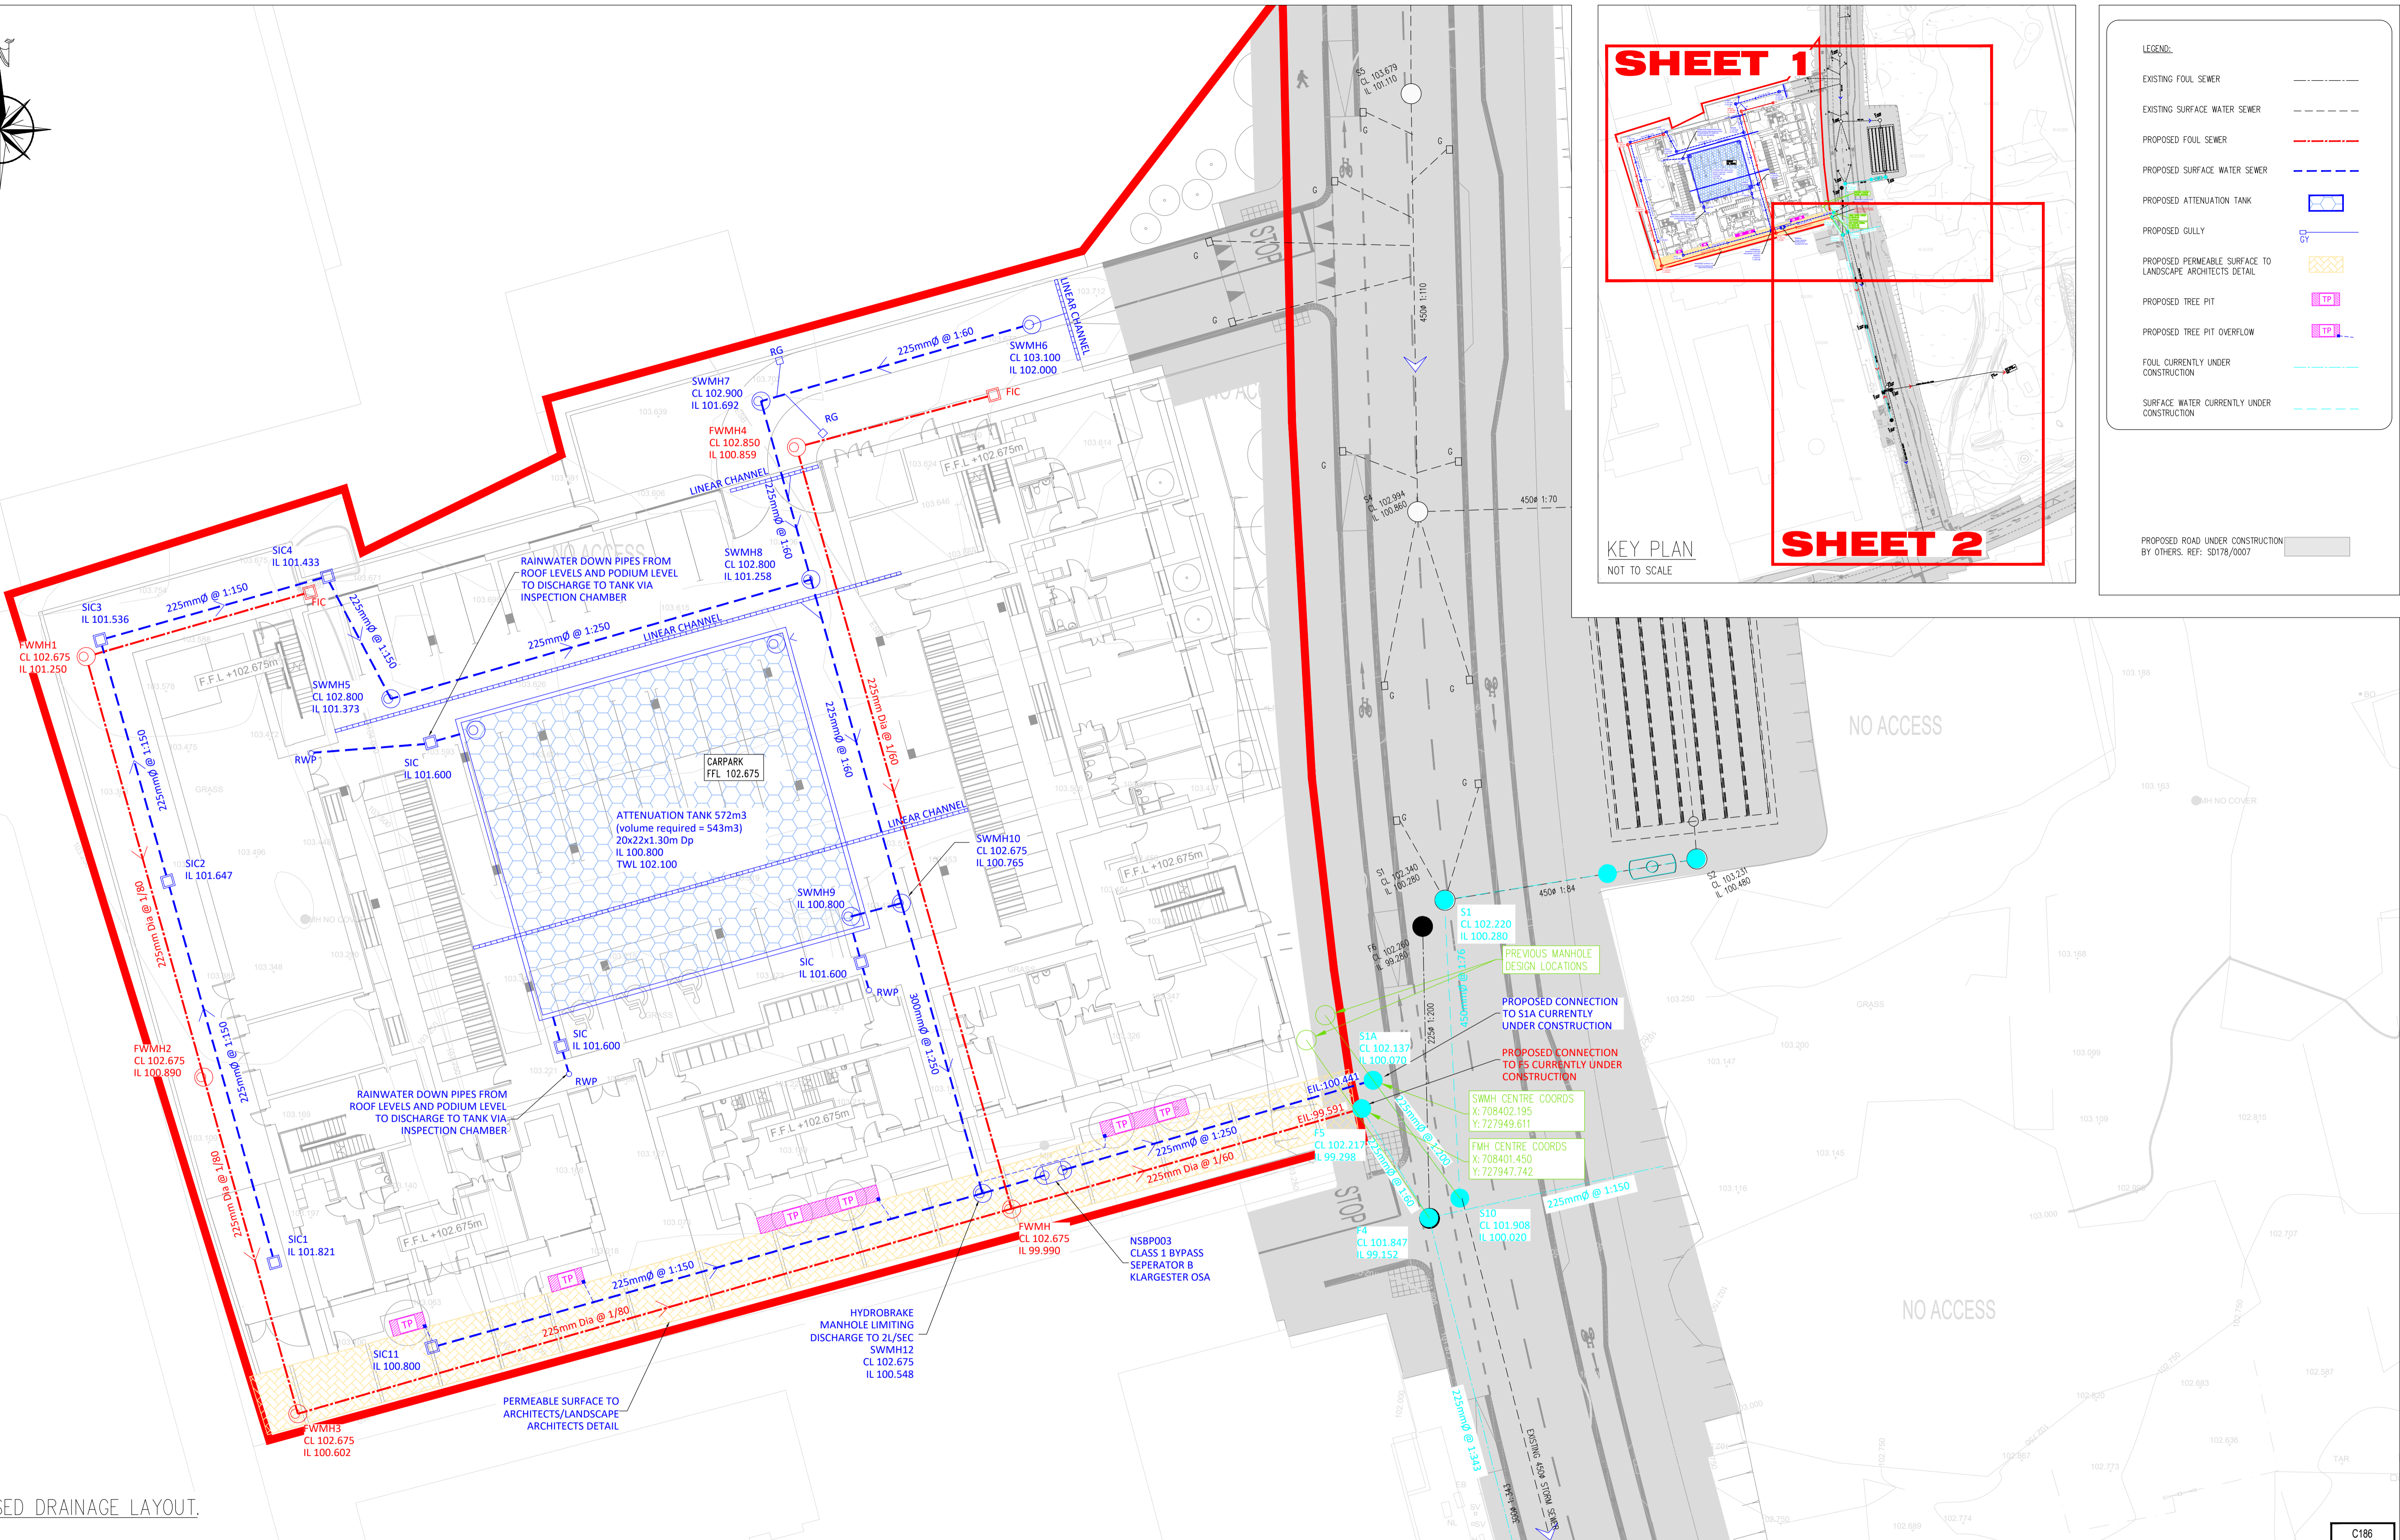

PROPOSED DRAINAGE LAYOUT.
SCALE= 1:200

C186

PLANNING DRAWING.
NOT FOR CONSTRUCTION.
ALL LEVELS GIVEN ARE
RELATIVE TO ORDNANCE DATUM.
THIS DRAWING HAS BEEN ISSUED FOR INFORMATION
PURPOSES ONLY AND MUST NOT BE USED
FOR CONSTRUCTION UNDER ANY CIRCUMSTANCES

NOTES

- For setting out refer to Architect's drawings.
- This drawing to be read in conjunction with all other Architectural and Engineering drawings and all other relevant drawings and Specifications.
- DO NOT SCALE THIS DRAWING. Use figured dimensions only.
- No part of this document may be reproduced or transmitted in any form or stored in any retrieval system of any nature without the written permission as copyright holder except as agreed.
- Ordnance Survey Ireland Licence Number EN 0074020

Rev. No.	Date	REVISION NOTE	Dim. By	Chkd. By

Architect	Coady Architects			
Project	Belgard Square North Tallaght			
Title	Proposed Drainage Layout Sheet 1 Of 2			
Dwg. No.	TAL-CSC-ZZ-XX-DR-C-0003			
Date	Dim by	Chkd by	Apprd by	Scale
28.04.2020	AB	GS	NB	1:200 @A1

CS Consulting Group
DUBLIN | LONDON | LIMERICK

Head Office
19-22 Dame Street, Dublin 2.
T: +353 (0)1 5480863 F: +353 (0)1 9011355
e: info@csconsulting.ie
w: www.csconsulting.ie

Quality Environment I.S. EN ISO 9001:2008
NSAI Certified Energy I.S. EN ISO 14001:2004
Health & Safety I.S. EN ISO 50001:2011 OHSAS 18001:2007